 


This drawing has been created electronically.

Handwritten or manual revisions to the drawing are only valid when accompanied by the design engineer's initials.


Do not scale drawings. Check and verify all dimensions and information on the drawings and report all errors or omissions to the Consultant before proceeding with the work. This drawing shall not be reproduced in any manner, in part or in whole, for any project other than that for which it was prepared. This drawing, and all design concepts it contains, are an instrument of professional service and remain the property of Gerrits Engineering.

This drawing may have been reduced.



No.	Issuance Description	YYMMDD
1.	ISSUED FOR SITE PLAN APPROVAL	20/12/17
2.	ISSUED FOR SITE PLAN APPROVAL	21/03/24

EXTERIOR LUMINAIRE SCHEDULE							
SYMBOL	TYPE MARK	DESCRIPTION	MANUFACTURER	CATALOG NUMBER	LAMP(S)	SUPPLY VOLTAGE	WATTS
	XA	WALL PACK: TYPE 4 FORWARD THROW DISTRIBUTION, 8200 LUMEN, FULL CUTOFF, HIGH EFFICIENCY, UL LISTED, IP66 HOUSING, NEMA TWISTLOCK PHOTOCONTROL RECEPTACLE, 120V PHOTOCONTROL. MOUNT AT 3.658 m (12') AFF.	COOPER	GAW-AF-02-LED-U-T4FT-600-P120-4	LED-4000K	120VAC	66W
	XB	WALL PACK: TYPE 2 DISTRIBUTION, 8200 LUMEN, FULL CUTOFF, HIGH EFFICIENCY, UL LISTED, IP66 HOUSING, NEMA TWISTLOCK PHOTOCONTROL RECEPTACLE, 120V PHOTOCONTROL. MOUNT AT 3.048 m (10') AFF.	COOPER	GAW-AF-02-LED-U-T2-600-P120-4	LED-4000K	120VAC	66W
	XC	WALL PACK: TYPE 4 WIDE DISTRIBUTION, 8200 LUMEN, FULL CUTOFF, HIGH EFFICIENCY, UL LISTED, IP66 HOUSING, NEMA TWISTLOCK PHOTOCONTROL RECEPTACLE, 120V PHOTOCONTROL. MOUNT AT 3.658 m (12') AFF.	COOPER	GAW-AF-02-LED-U-T4W-600-P120-4	LED-4000K	120VAC	66W

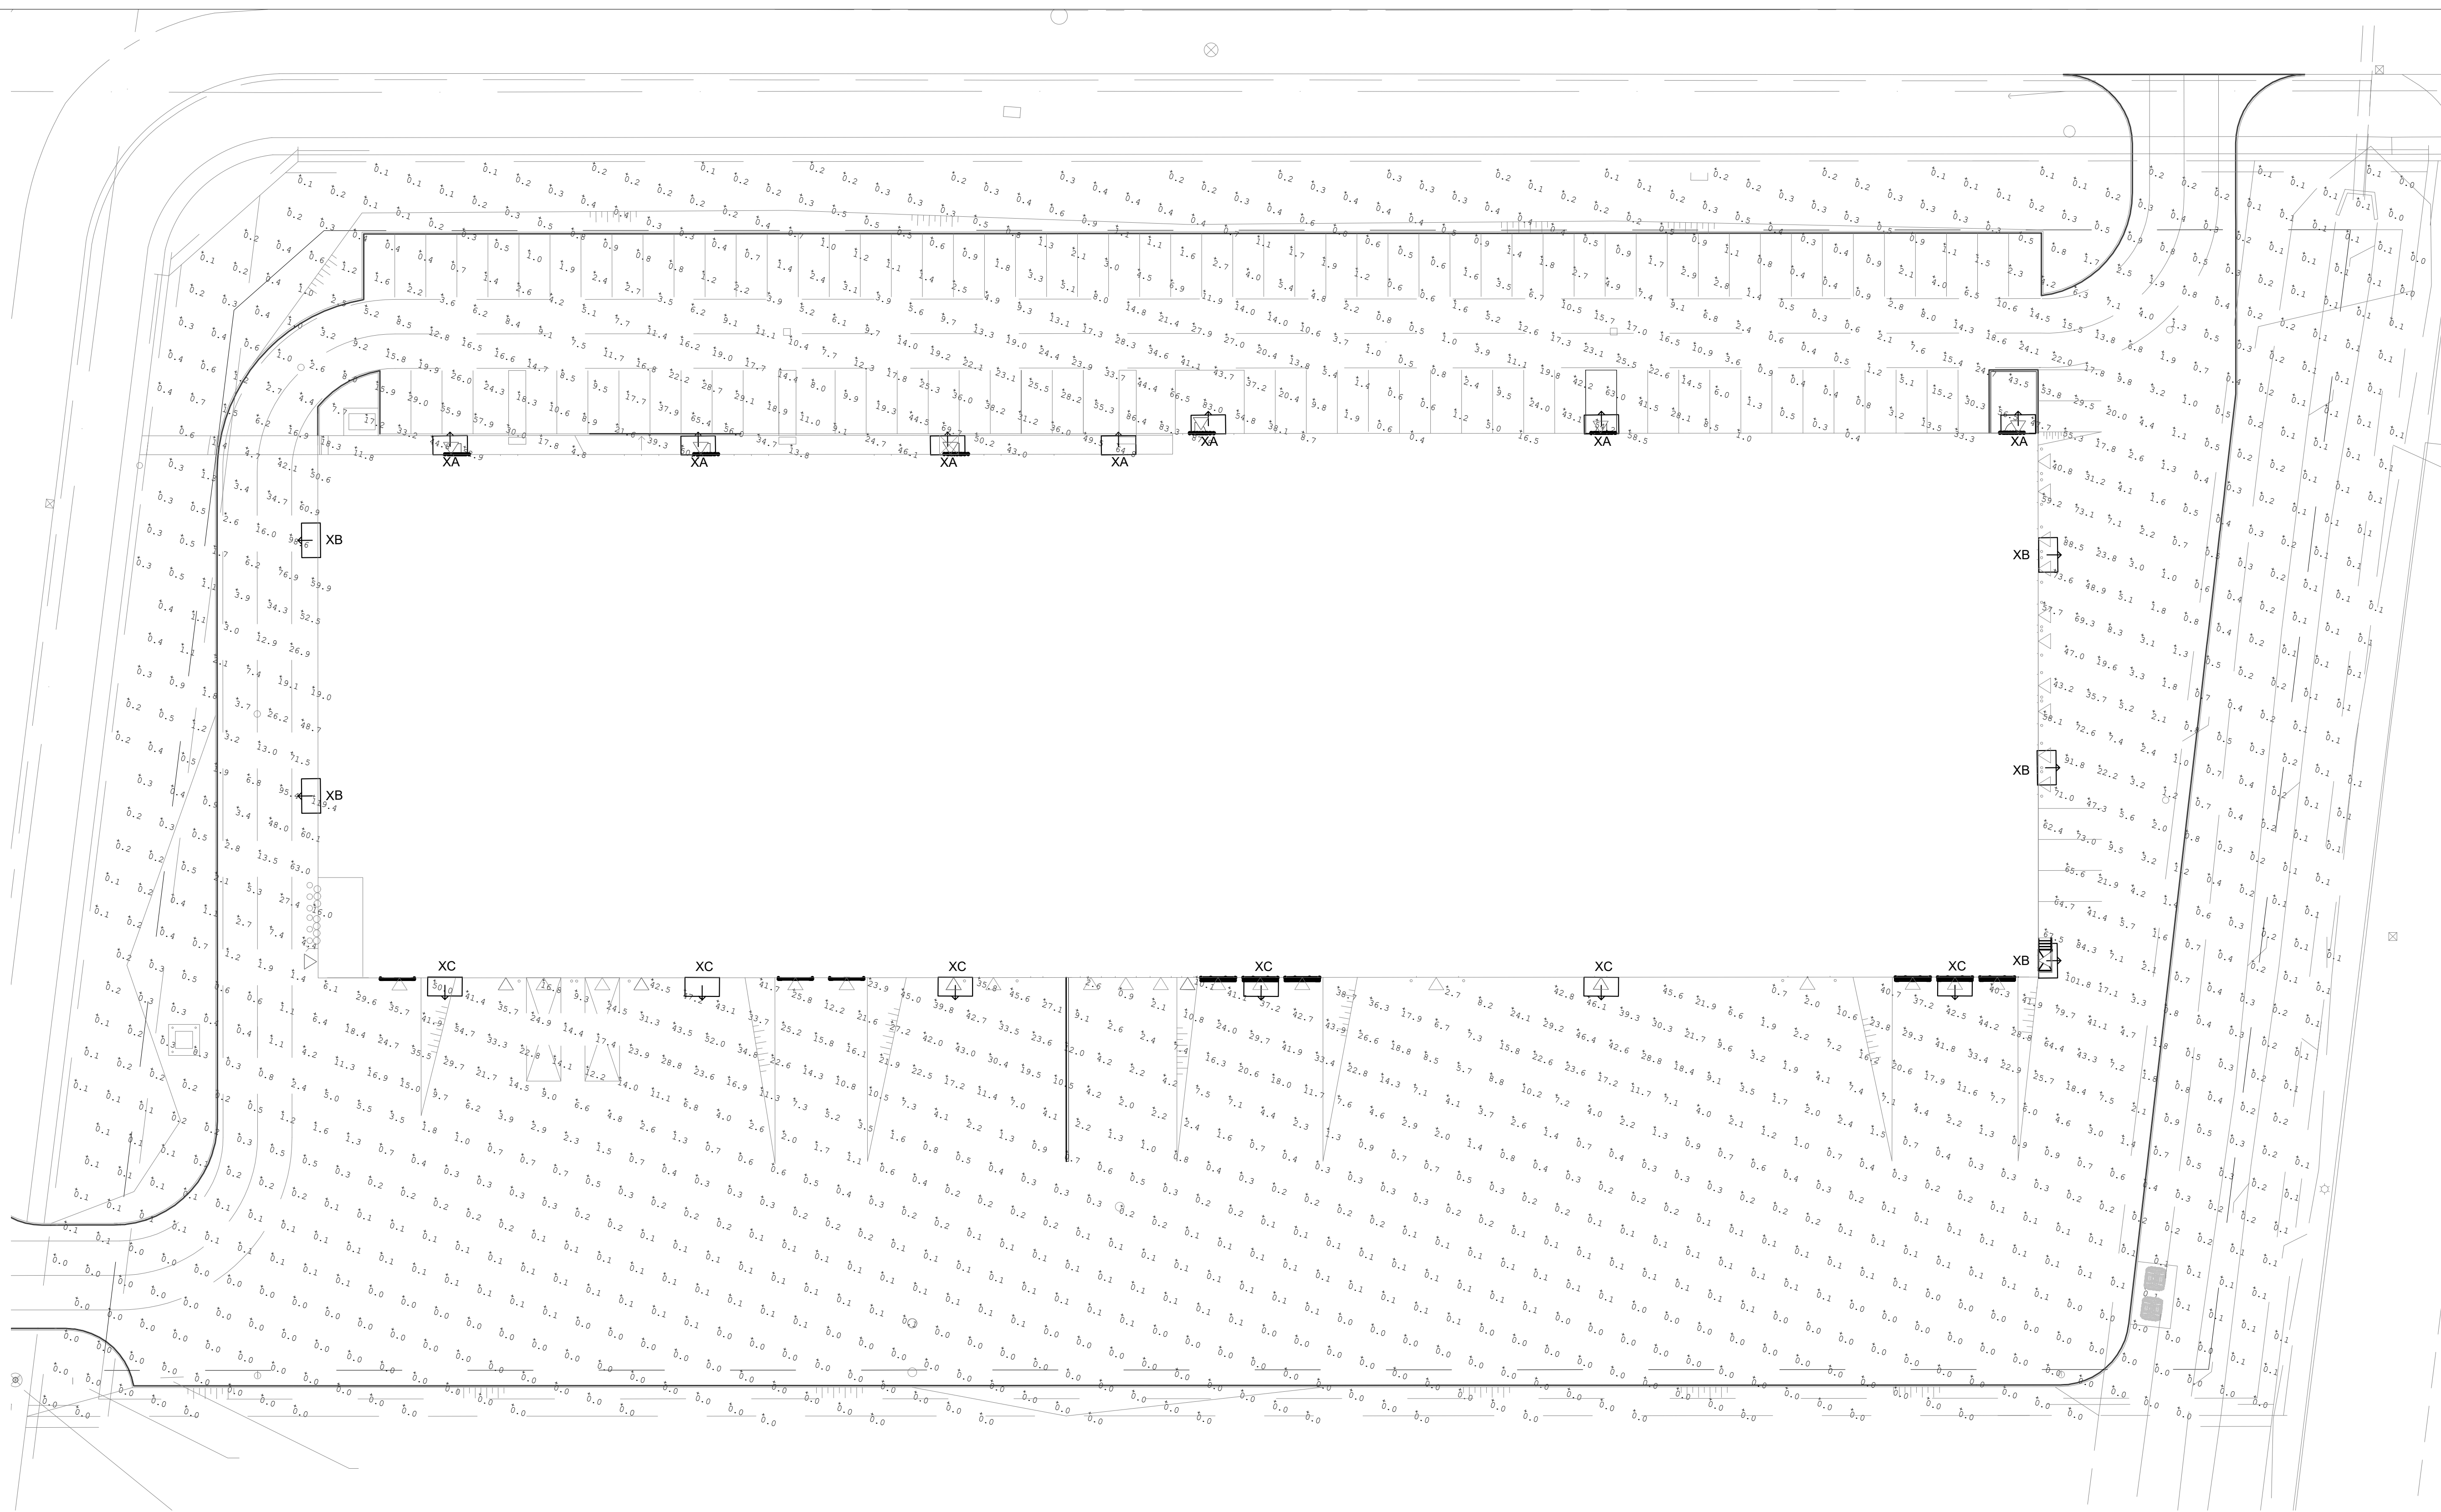

1 ELECTRICAL SITE PLAN
SCALE 1:300


ISSUED FOR:
SITE PLAN APPROVAL



Client
1 REID DRIVE
1 REID DRIVE, BARRIE, ON

Drawing:
PHOTOMETRICS

Project No.	109-258-19	Designed by:	MG	Checked by:	CP
Time Stamp:		Drawn by:	MG	Approved by:	CP
Orientation		Stamp			

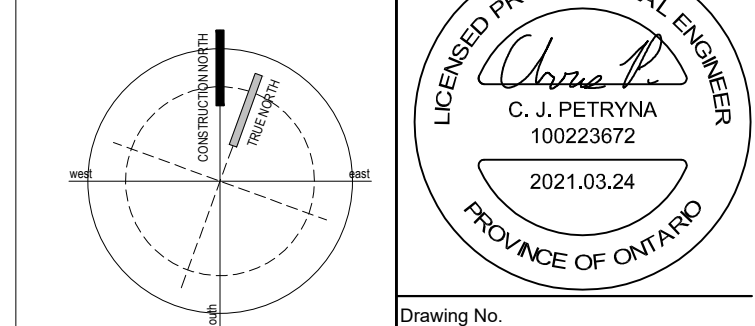

Drawing No. **E100**