


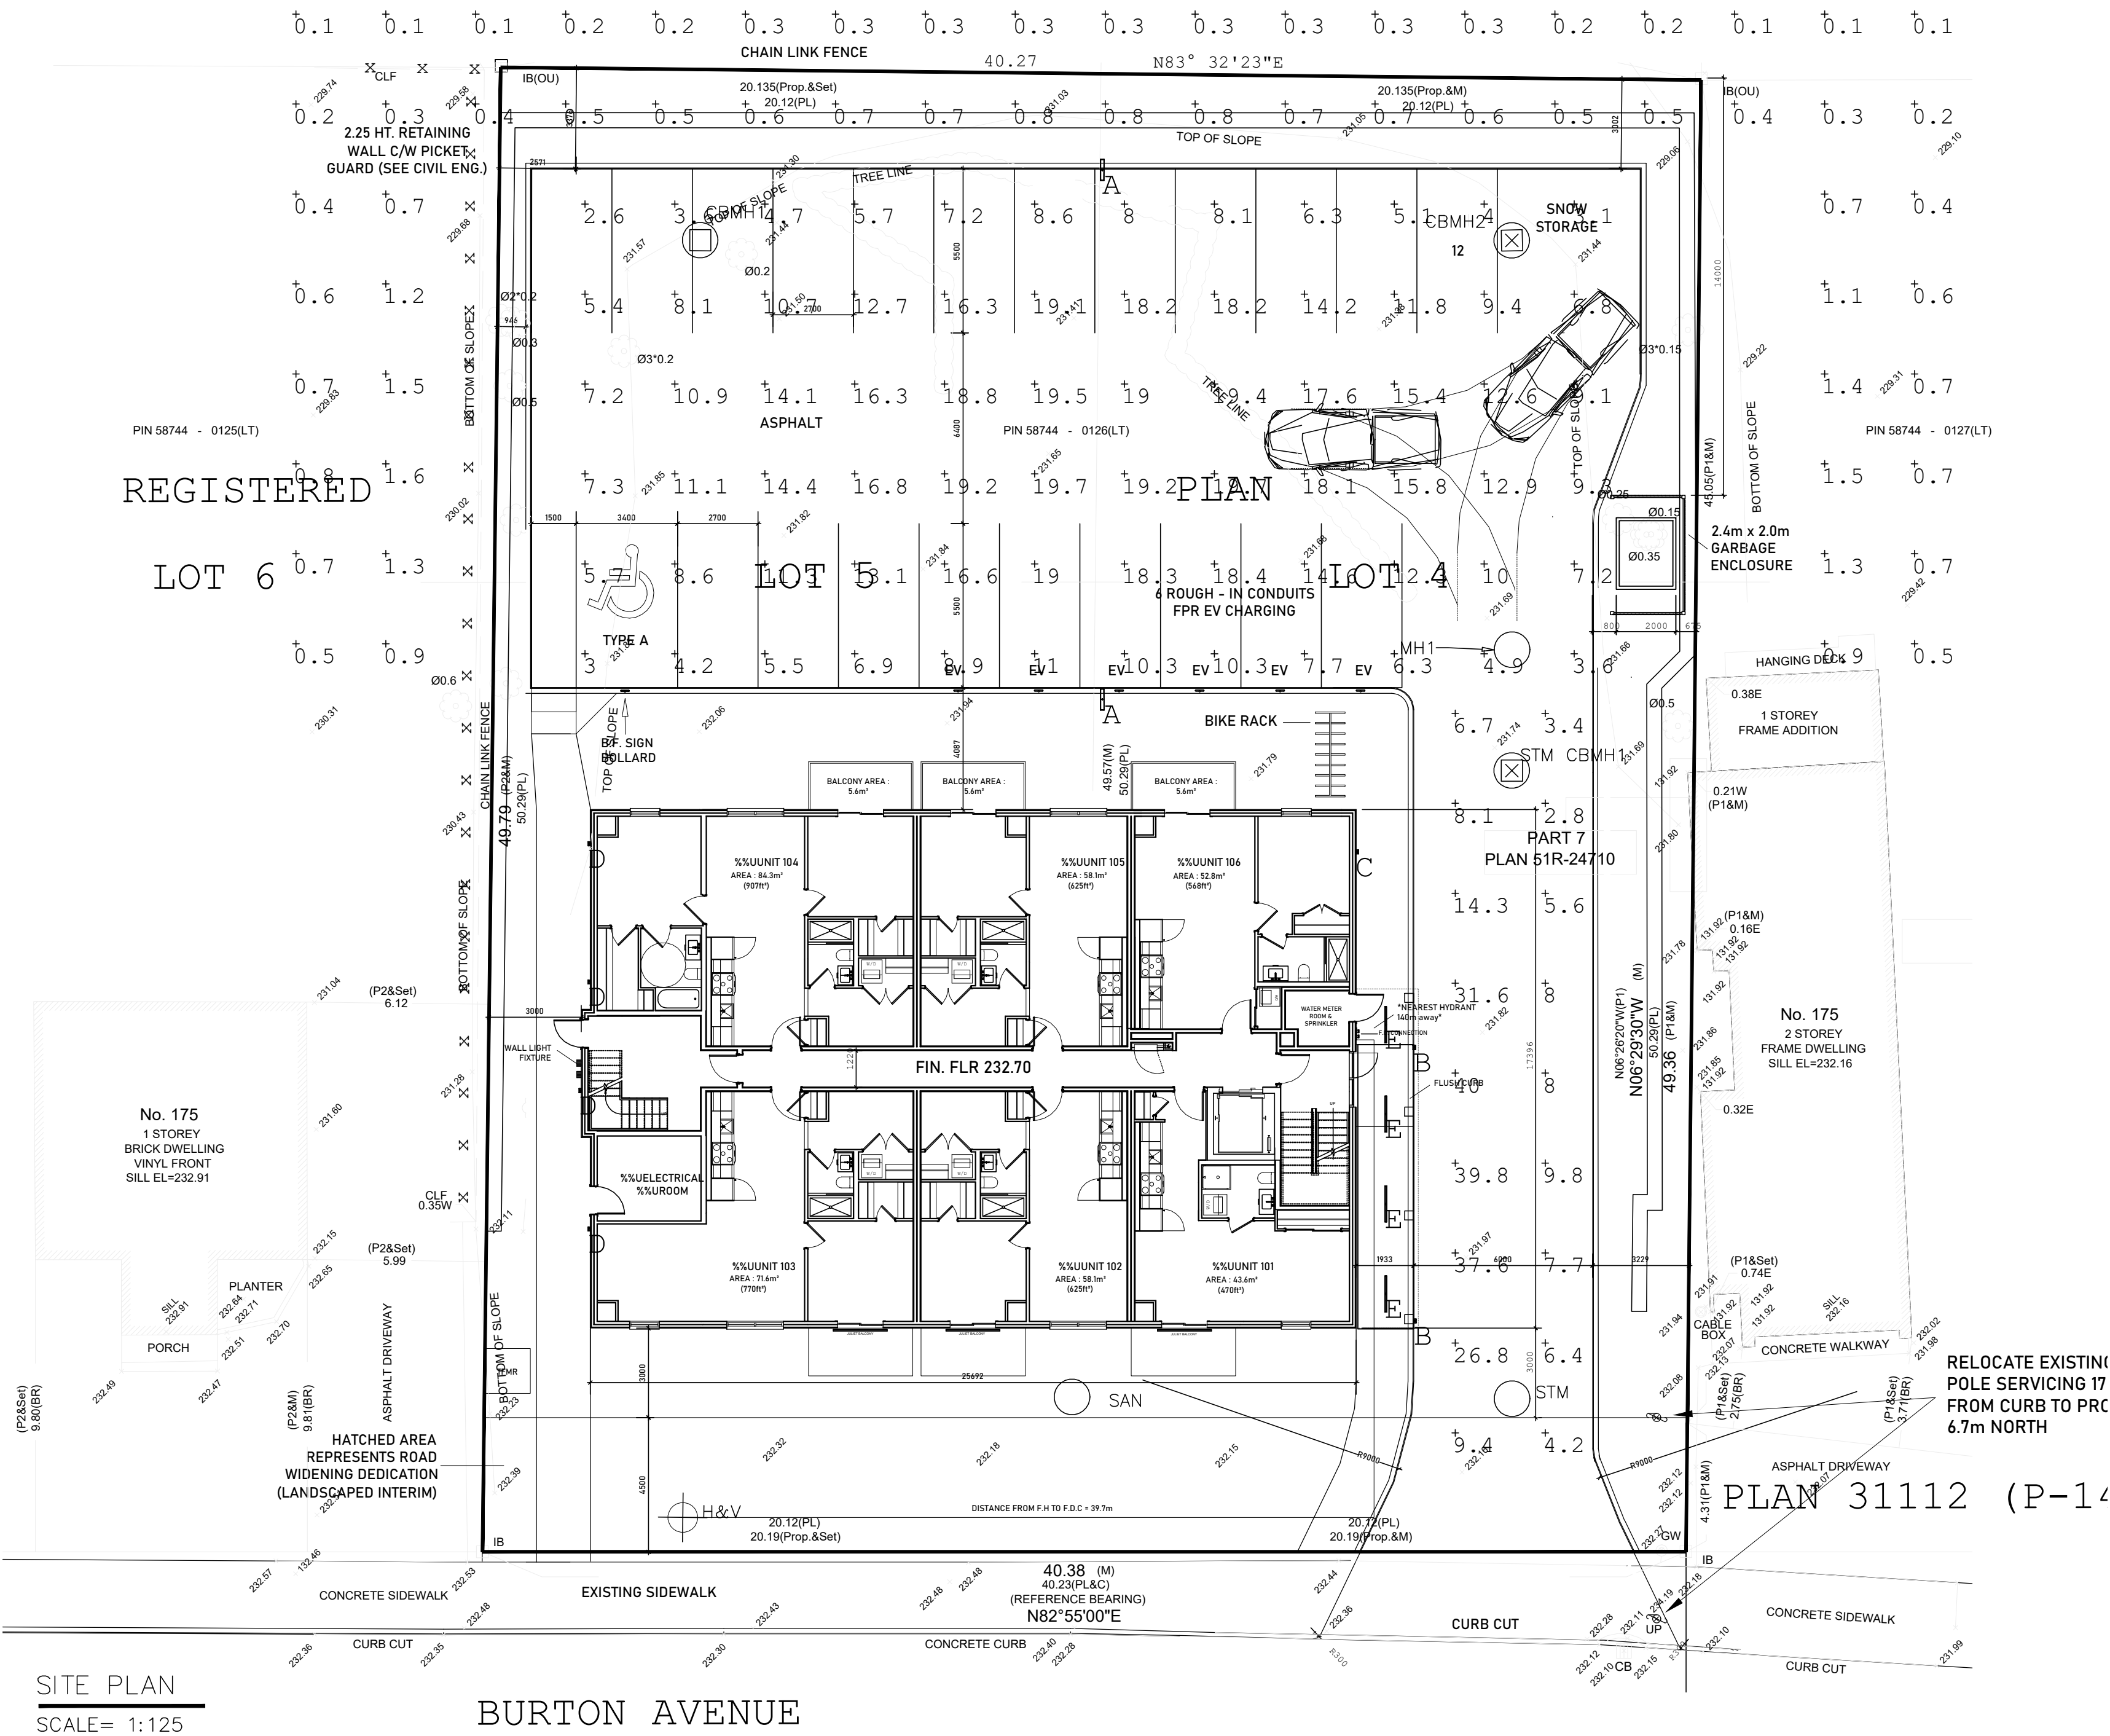

Luminaire Schedule									
Symbol	Qty	Label	Arrangement	Description	Tag	LLF	Luminaire Lumens	Luminaire Watts	Total Watts
	2	Parking Lot	SINGLE	BLDM-SD-120_277-CSL-M100-30K-CRI 80-3 BLS	A	0.900	4980	115	230
	2	Roadway Entrance Canopy	SINGLE	BLDN-SD_WM-120_277-HFSL-N10-30K-CRI 70-2-LV	B	0.900	568	11	22
	1	Roadway Entrance Wall	SINGLE	BLDN-SD_WM-120_277-HFSL-N10-30K-CRI 70-3-LV	C	0.900	637	11	11
	4	Pathway Entrance	SINGLE	BLDN-SD_WM-120_277-HFSL-N03-30K-CRI 70-2-LV	D	0.900	136	3	12
	4	Linear Canopy	SINGLE	V2SEALPD-EPDO-80-350-30-4FT	E	0.900	1401	14.42	57.68


Calculation Summary								
Label	CalcType	Units	Avg	Max	Min	Avg/Min	Max/Min	
Parking Lot	Illuminance	Lux	11.38	19.7	2.6	4.38	7.58	
Roadway	Illuminance	Lux	15.01	40.0	2.8	5.36	14.29	
Trespass	Illuminance	Lux	0.47	1.6	0.1	4.70	16.00	



KEY PLAN
NTS

ISM Architects Inc.
97 Toronto Street
Burlington, ON L7R 1V1
T: 705.726.2342
E: ian@ismarchitects.ca


No.	ISSUE/REVISION	DATE
1	CLIENT REVIEW	APR 23 19
2	PRE-SPC	MAY 16 19
3	RENTAL UNIT CONVERS	OCT 16 19
4	2ND SUBMISSION	DEC 23 22
5	PER MAY 19 COMMENTS	JUN 01 23
6	RESUBMISSION TO CITY	JUL 15 22
7	STATS PER PLANNER	SEP 14 22
8	2ND B.F. CAR	NOV 03 22
9	REDUCED UNITS	NOV 11 22
10	ADDED BALCONIES	NOV 17 22
11	PER CITY PLANNER	NOV 19 22
12	PER CITY COMMENTS	NOV 23 22
13	B.F. PARKING RAMP	JAN 24 23
14	PER CITY MEETING	FEB 24 23
15	SUBMIT FOR SPC	APR 17 23
16	LIGHT LEVELS ON DRIVE	JUL 07 23
17	RELOCATED POLE	OCT 27 23
18	PER UPDATED LIGHTING	NOV 08 23

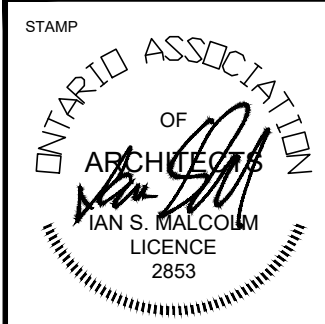

The registered architect has checked and verified all dimensions and report all errors and omissions to the Architect before proceeding with the work.

A. Seal No. B. Sheet No. where defined.

The ideas/designs included herein are the sole property of Ian S. Malcolm Architect. They shall not be used, copied, or reproduced without the written consent of Ian S. Malcolm Architect and full payment of associated design fees.

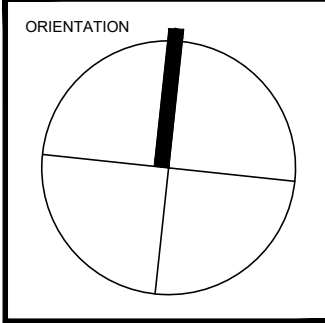

CLIENT
MARIA ROZENTS
343 SUGAR MAPLE LN.
RICHMOND HILL
ON L4C4G3
4167100484
mrozents@gmail.com

PROJECT
181 BURTON-
RESIDENTIAL
FOUR STORY 24 UNIT
APARTMENT BUILDING

PROJECT INFORMATION
PROJECT No.: 194080
DRAWN BY: JB AF
CHECKED BY: ISM
DATE: NOV 08 2023
SCALE: AS NOTED

DRAWING
SITE PLAN
SITE LIGHTING

DRAWING No.
E.1