

Do not scale the drawings.
 This Drawing is Not To Be Used For Construction Until Signed
 By The Architect.

Date:

Revisions:		Date:
No.:	Revision:	


1	ISSUED FOR SPA	NOV 13, 2023
No.:	Issued For:	Date:

Client:
 Crown Communities Developments Inc.


126 Bradford St, Barrie, ON L4N 3B3
 Proposed Residential Development

Drawing Title:
Lighting Site Plan


Scale:
 1 : 150
 Drawn by:
 F.C.
 Checked by:
 F.C.
 Project No.:
 23-166
 Date:
 NOV 28, 2023
 Drawing No.:

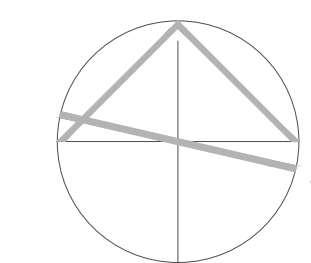

E1.00

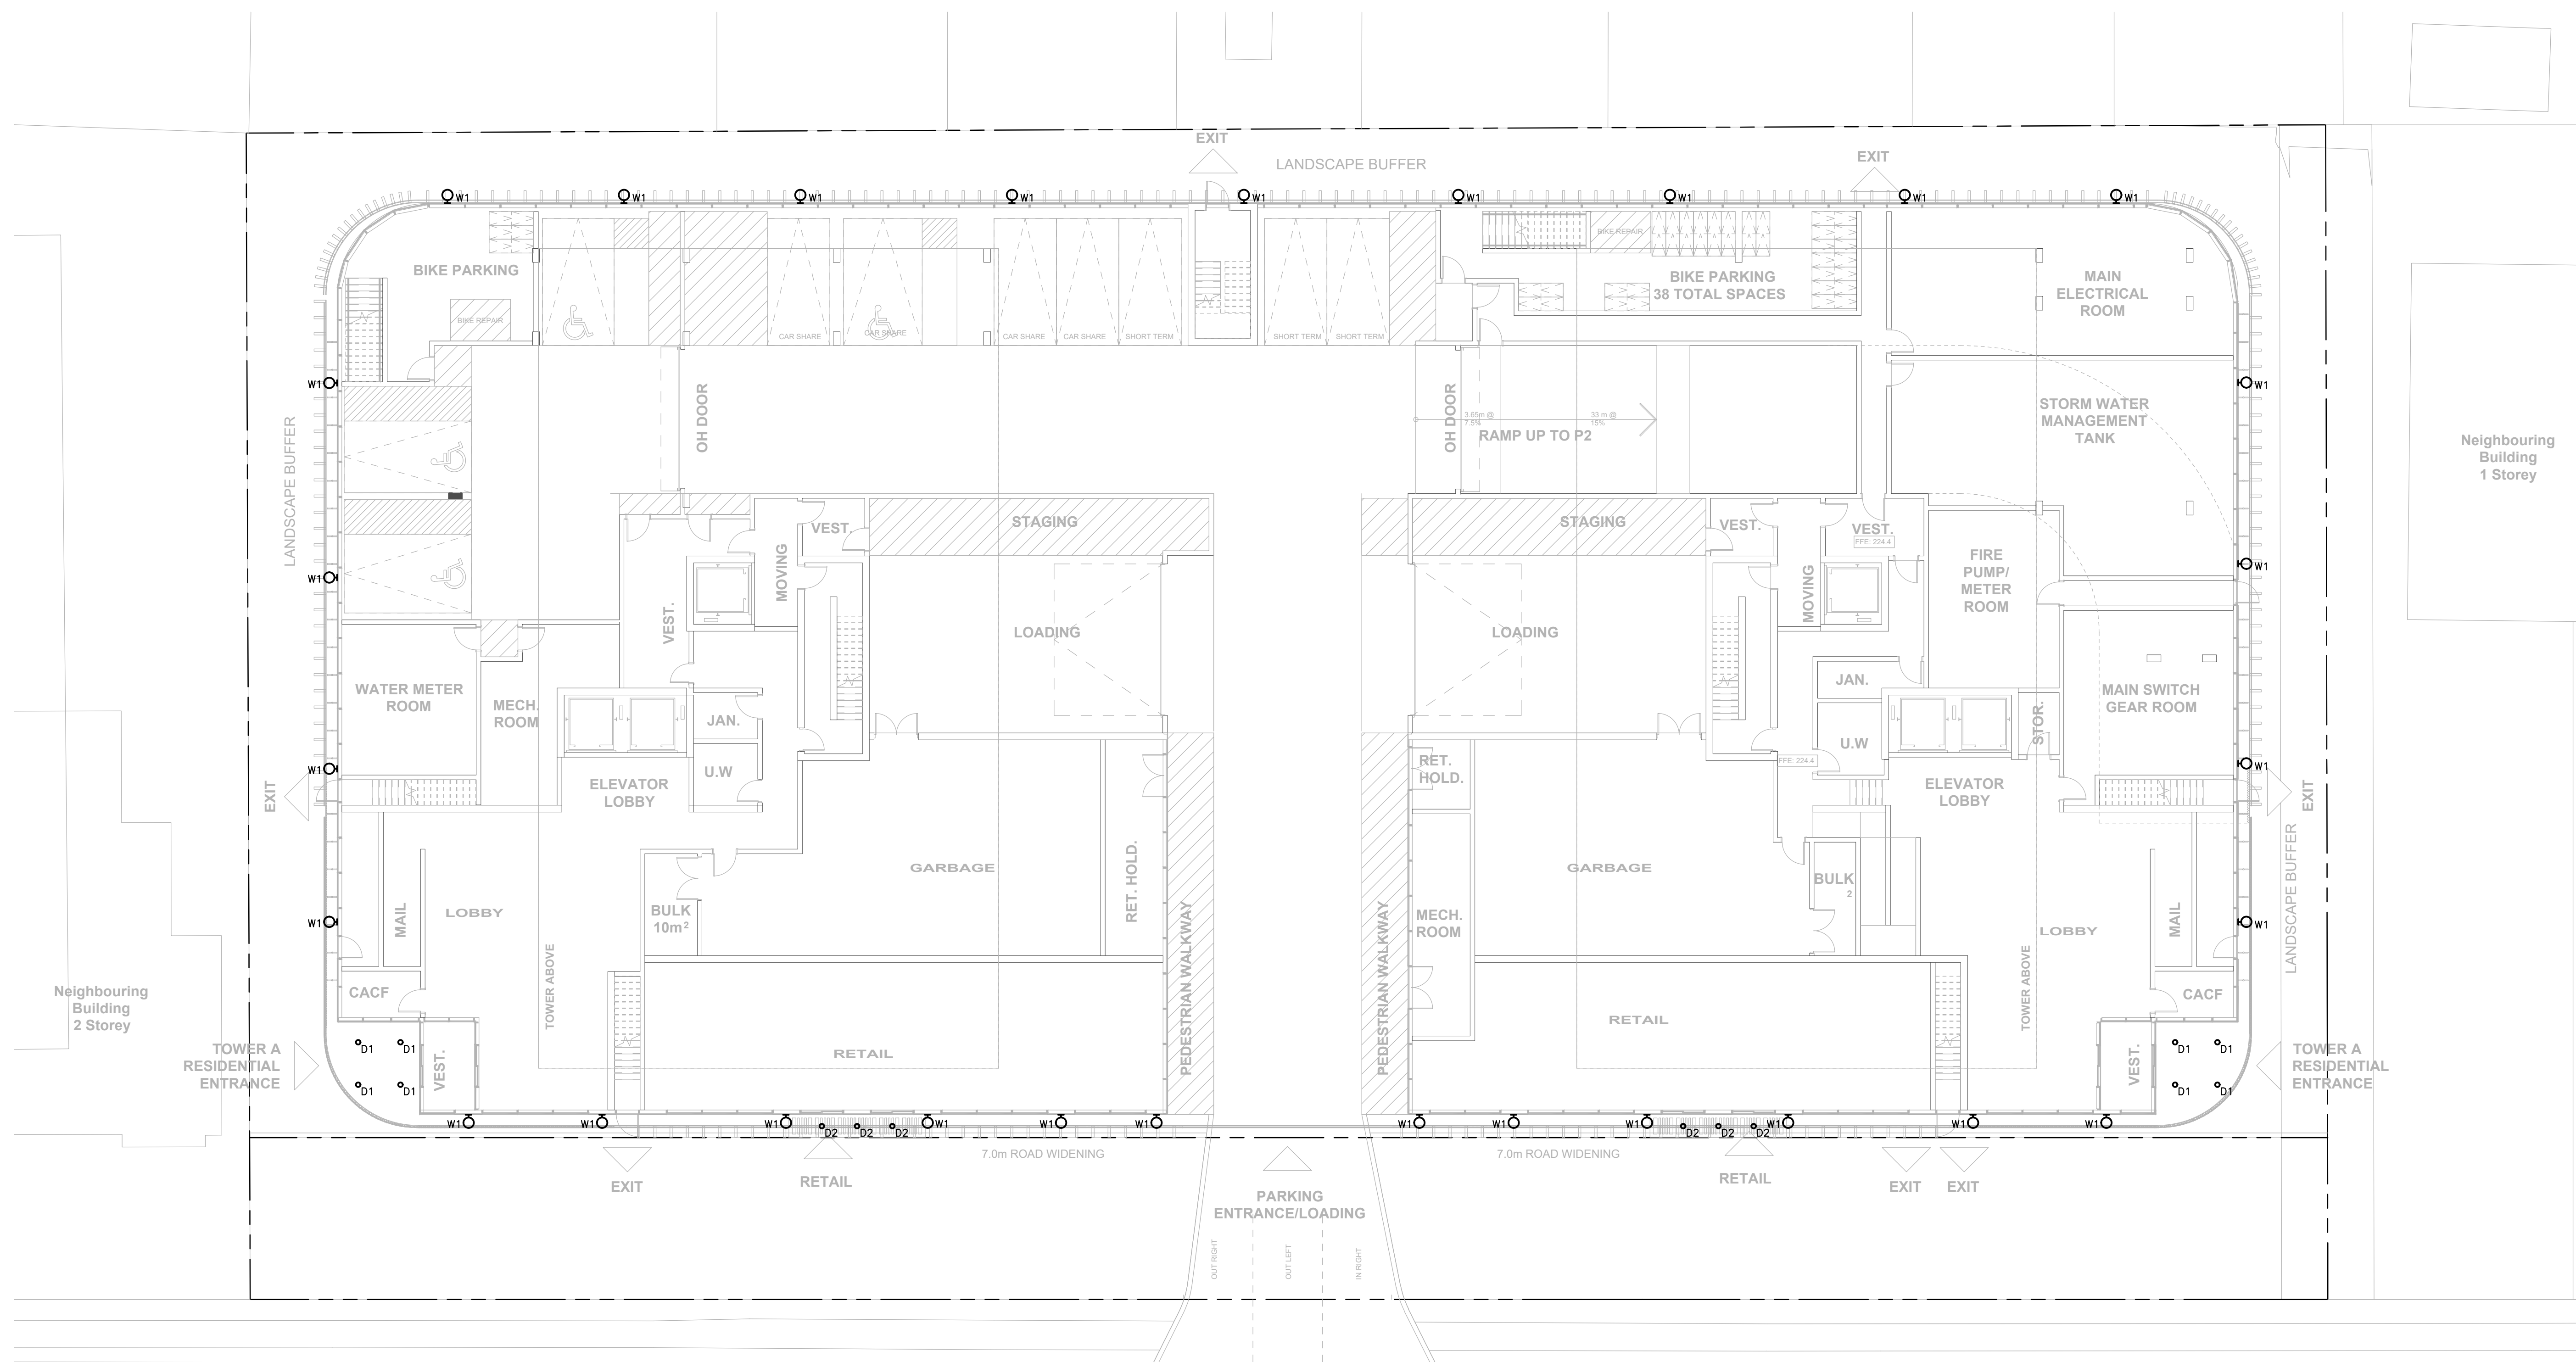

BRADFORD STREET

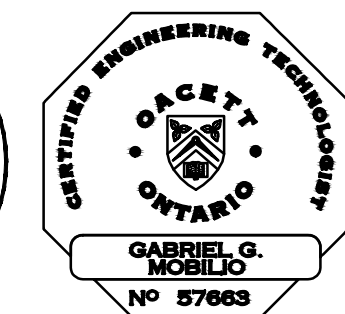

Do not scale the drawings.
 This Drawing is Not To Be Used For Construction Until Signed
 By The Architect.
 Date:

Revisions:		
No.	Revision	Date


1	ISSUED FOR SPA	NOV 13, 2023
---	----------------	--------------

Client:
Crown Communities Developments Inc.


126 Bradford St, Barrie, ON L4N 3B3
 Proposed Residential Development

Drawing Title:
**Outdoor Amenity
 Lighting Plan - Level 7**

Scale: 1 : 150
 Drawn by: F.C.
 Checked by: F.C.
 Project No.: 23-166
 Date: NOV 28, 2023
 Drawing No.:

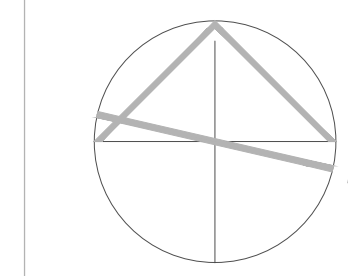

E1.01

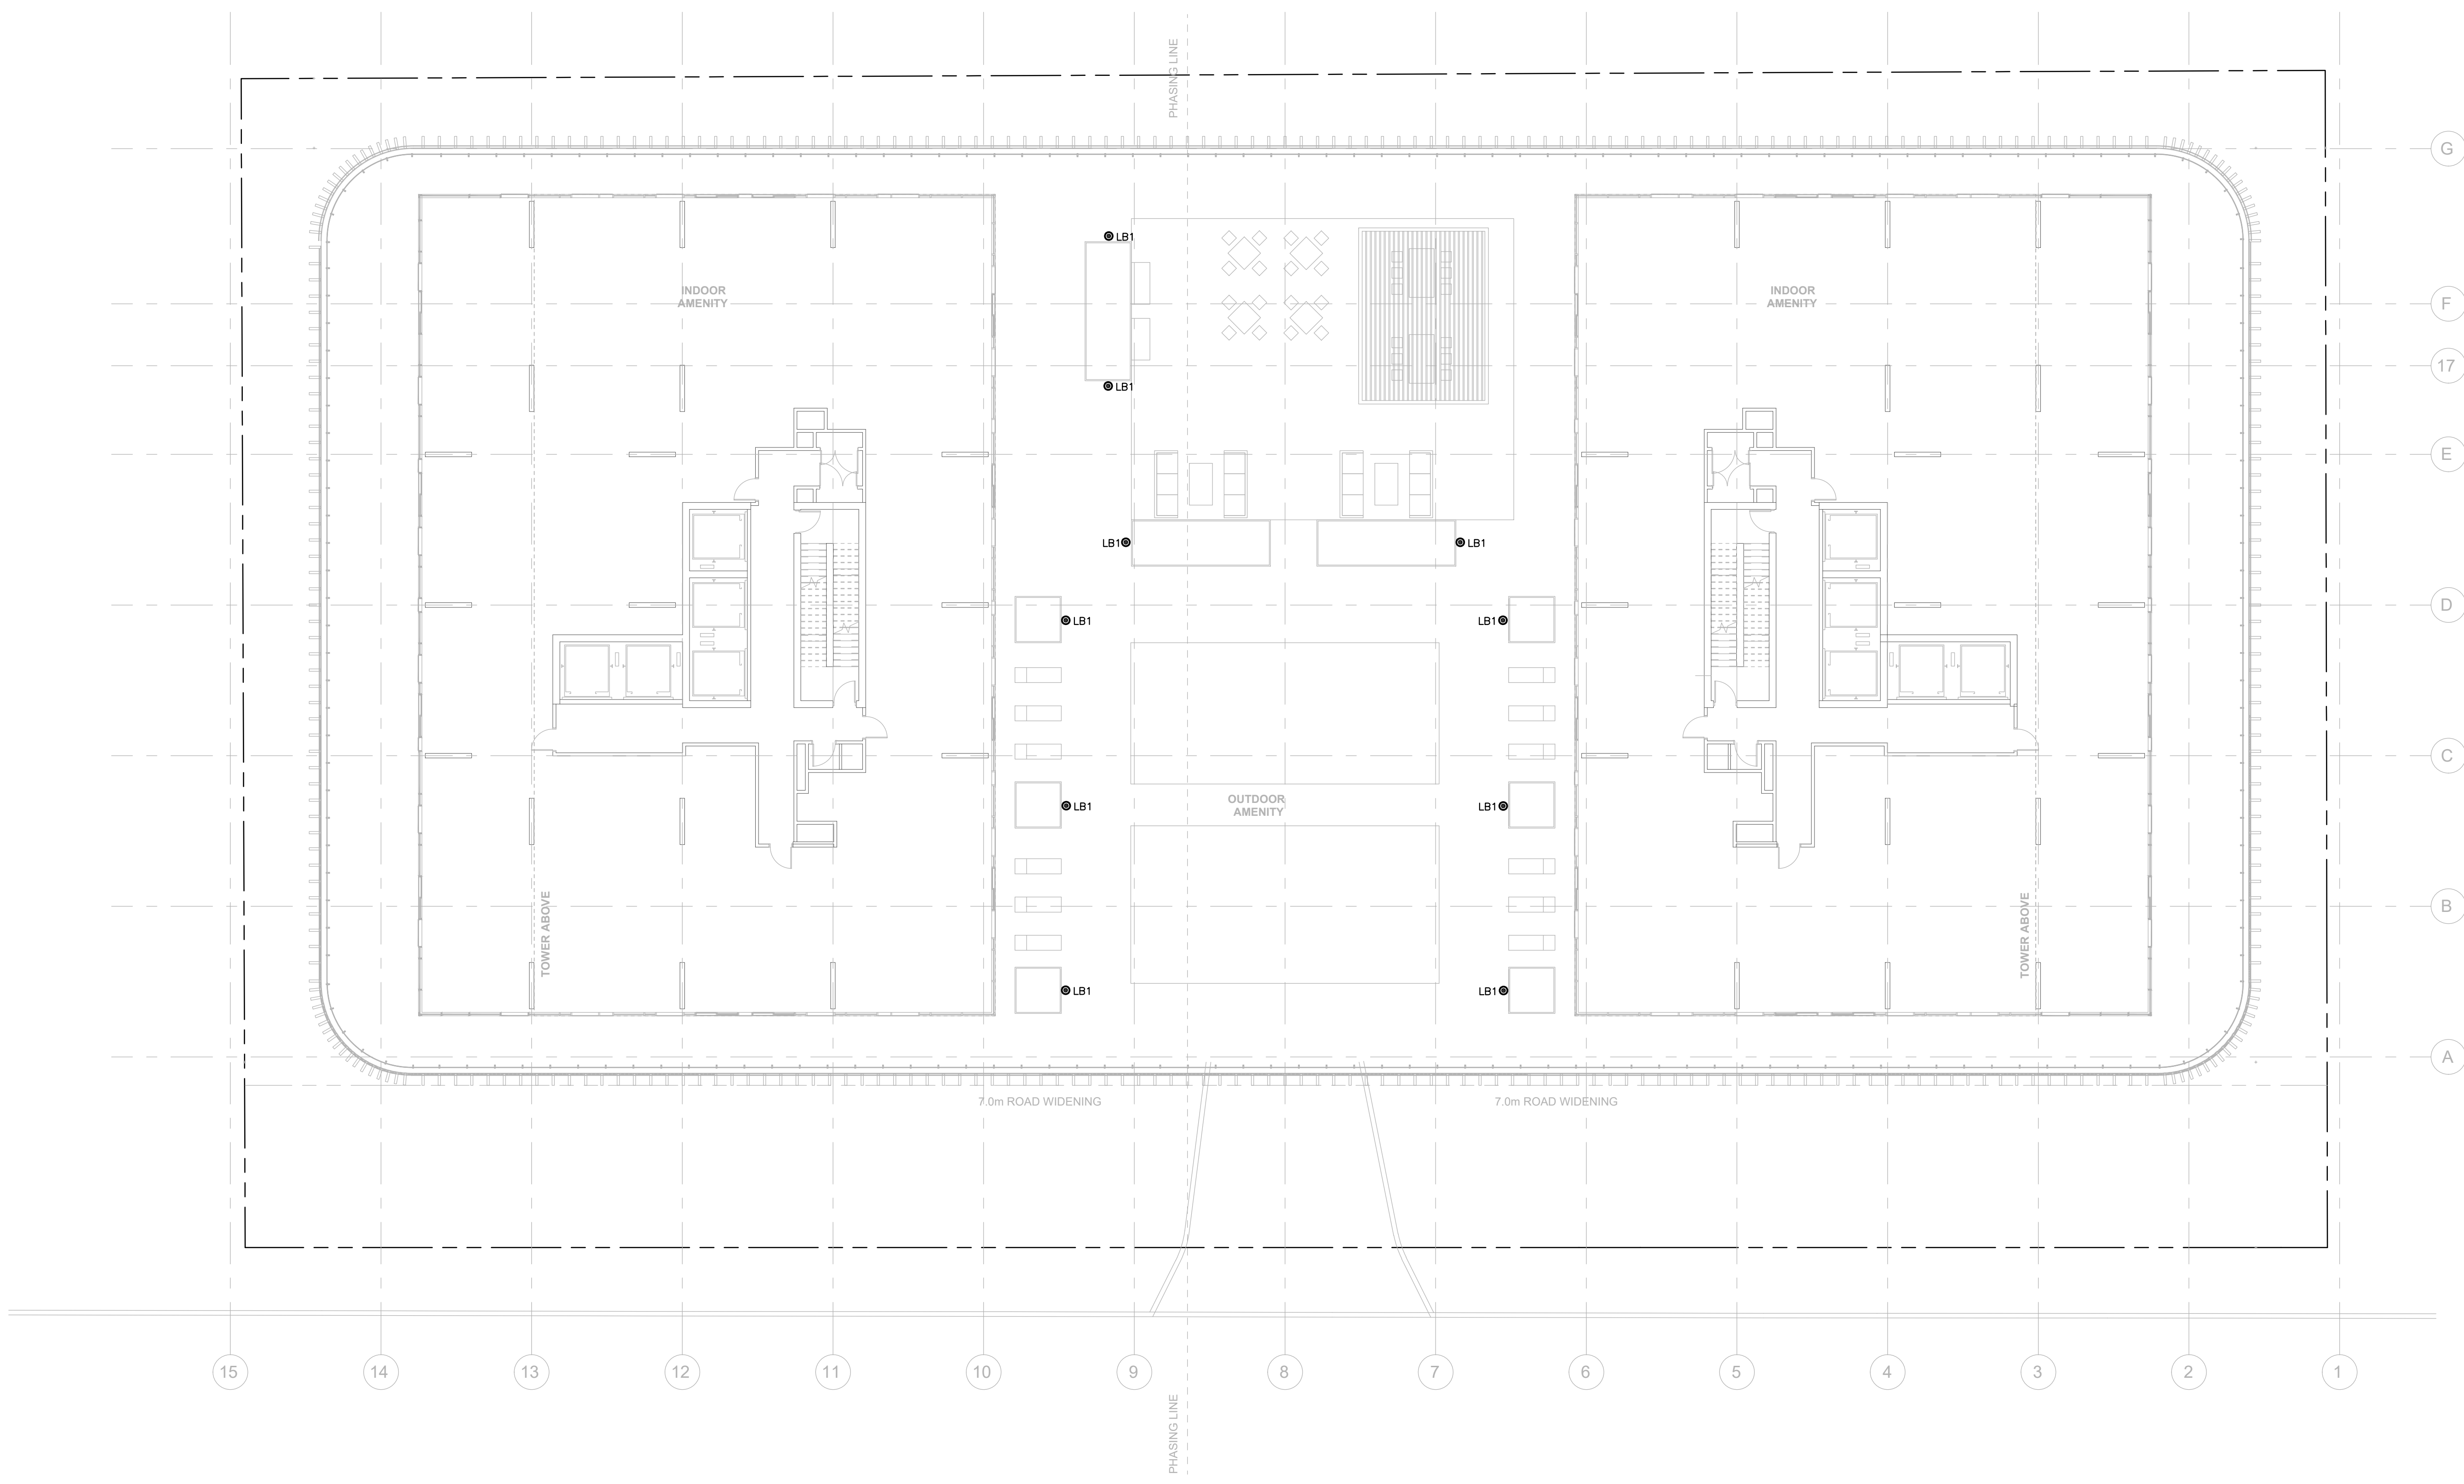

Do not scale the drawings.
 This Drawing is Not To Be Used For Construction Until Signed By The Architect.
 Date:

Revisions:		Date:
No.:	Revision:	


1	ISSUED FOR SPA	NOV 13, 2023
No.:	Issued For:	Date:

Client:
Crown Communities Developments Inc.


126 Bradford St, Barrie, ON L4N 3B3
 Proposed Residential Development



Drawing Title:
Lighting Site Plan Analysis

Scale:
 1 : 150
 Drawn by:
 F.C.
 Checked by:
 F.C.
 Project No.:
 23-166
 Date:
 NOV 28, 2023
 Drawing No.:

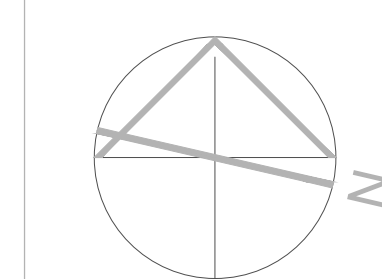

E1.01

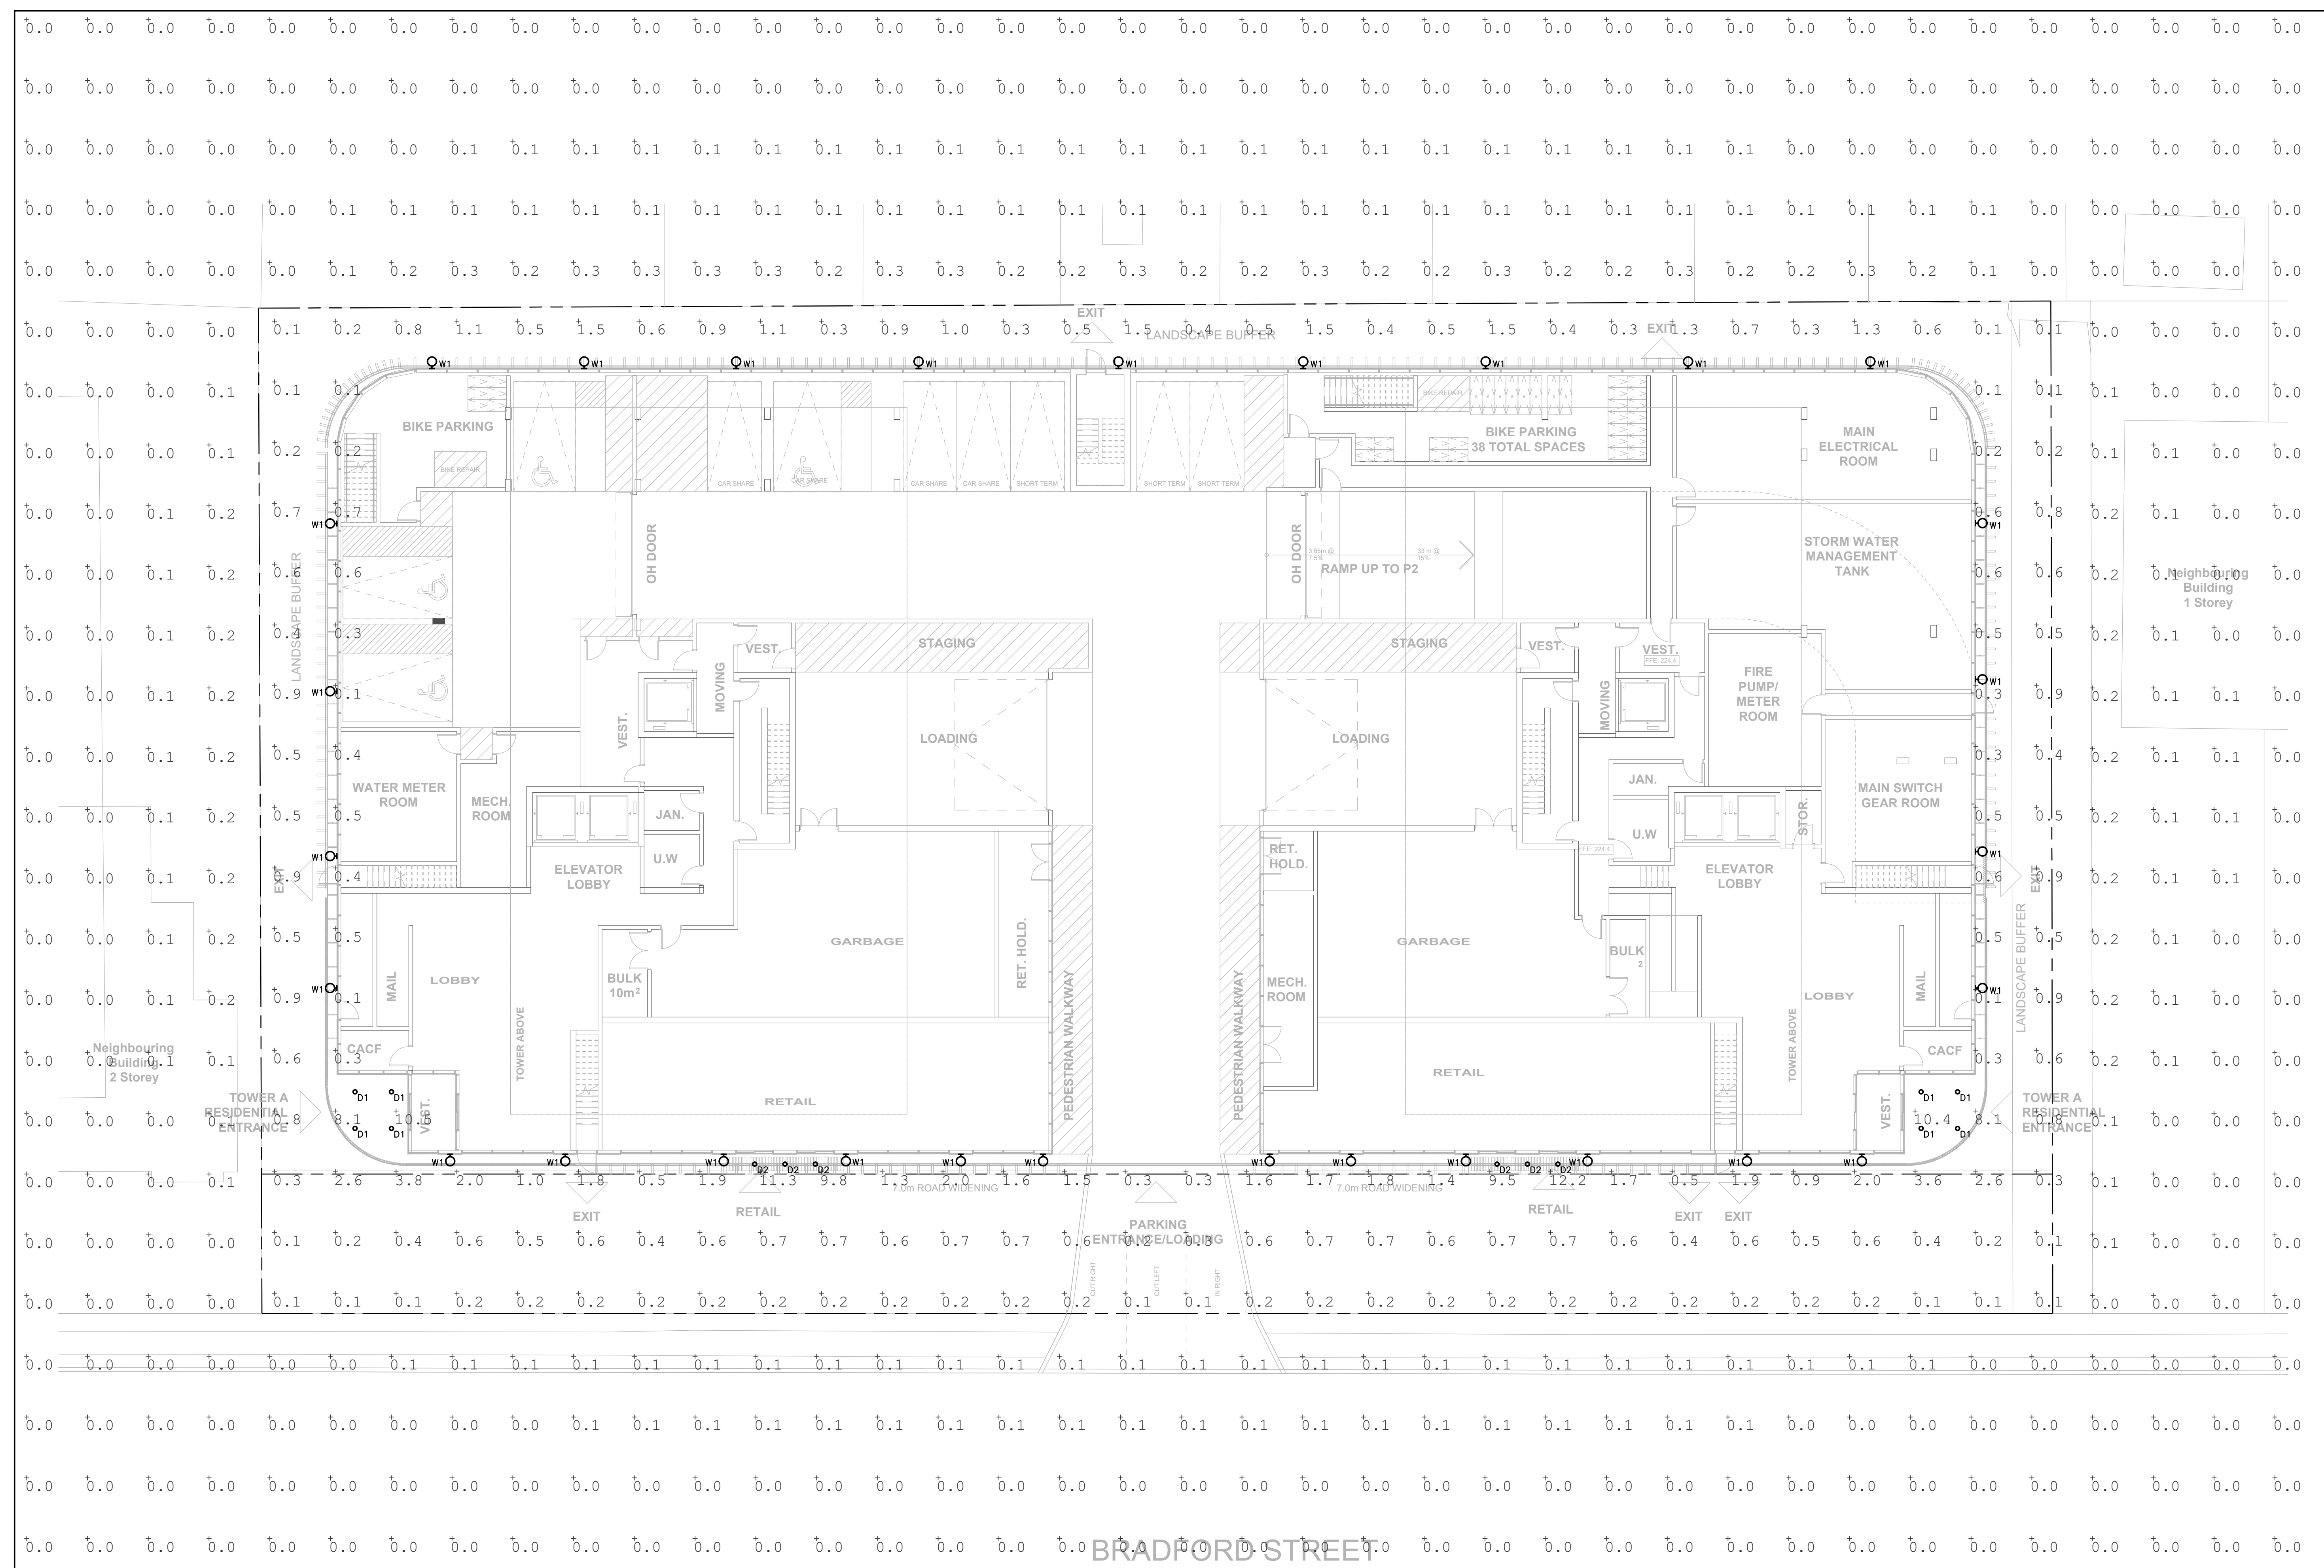

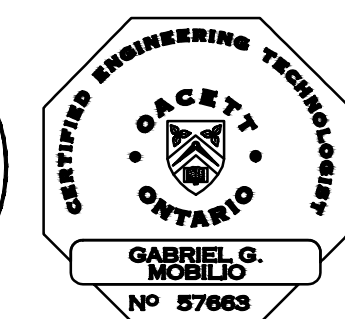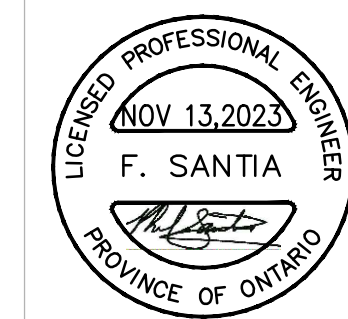

Do not scale the drawings.
 This Drawing is Not To Be Used For Construction Until Signed
 By The Architect.

Date:

Revisions:

No.	Revision:	Date:

1	ISSUED FOR SPA	NOV 13, 2023
---	----------------	--------------

No.	Issued For:	Date:

Client:
 Crown Communities Developments Inc.

126 Bradford St, Barrie, ON L4N 3B3
 Proposed Residential Development

Drawing Title:
**Outdoor Amenity Lighting
 Plan Analysis - Level 7**

Scale:

1 : 150

Drawn by:

F.C.

Checked by:

F.C.


Project No.:

23-166


Date:

NOV 28, 2023

Drawing No.:

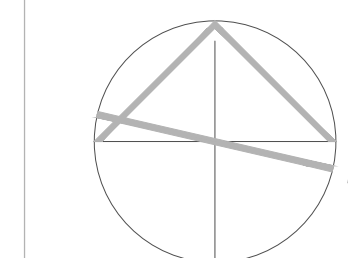


E1.03

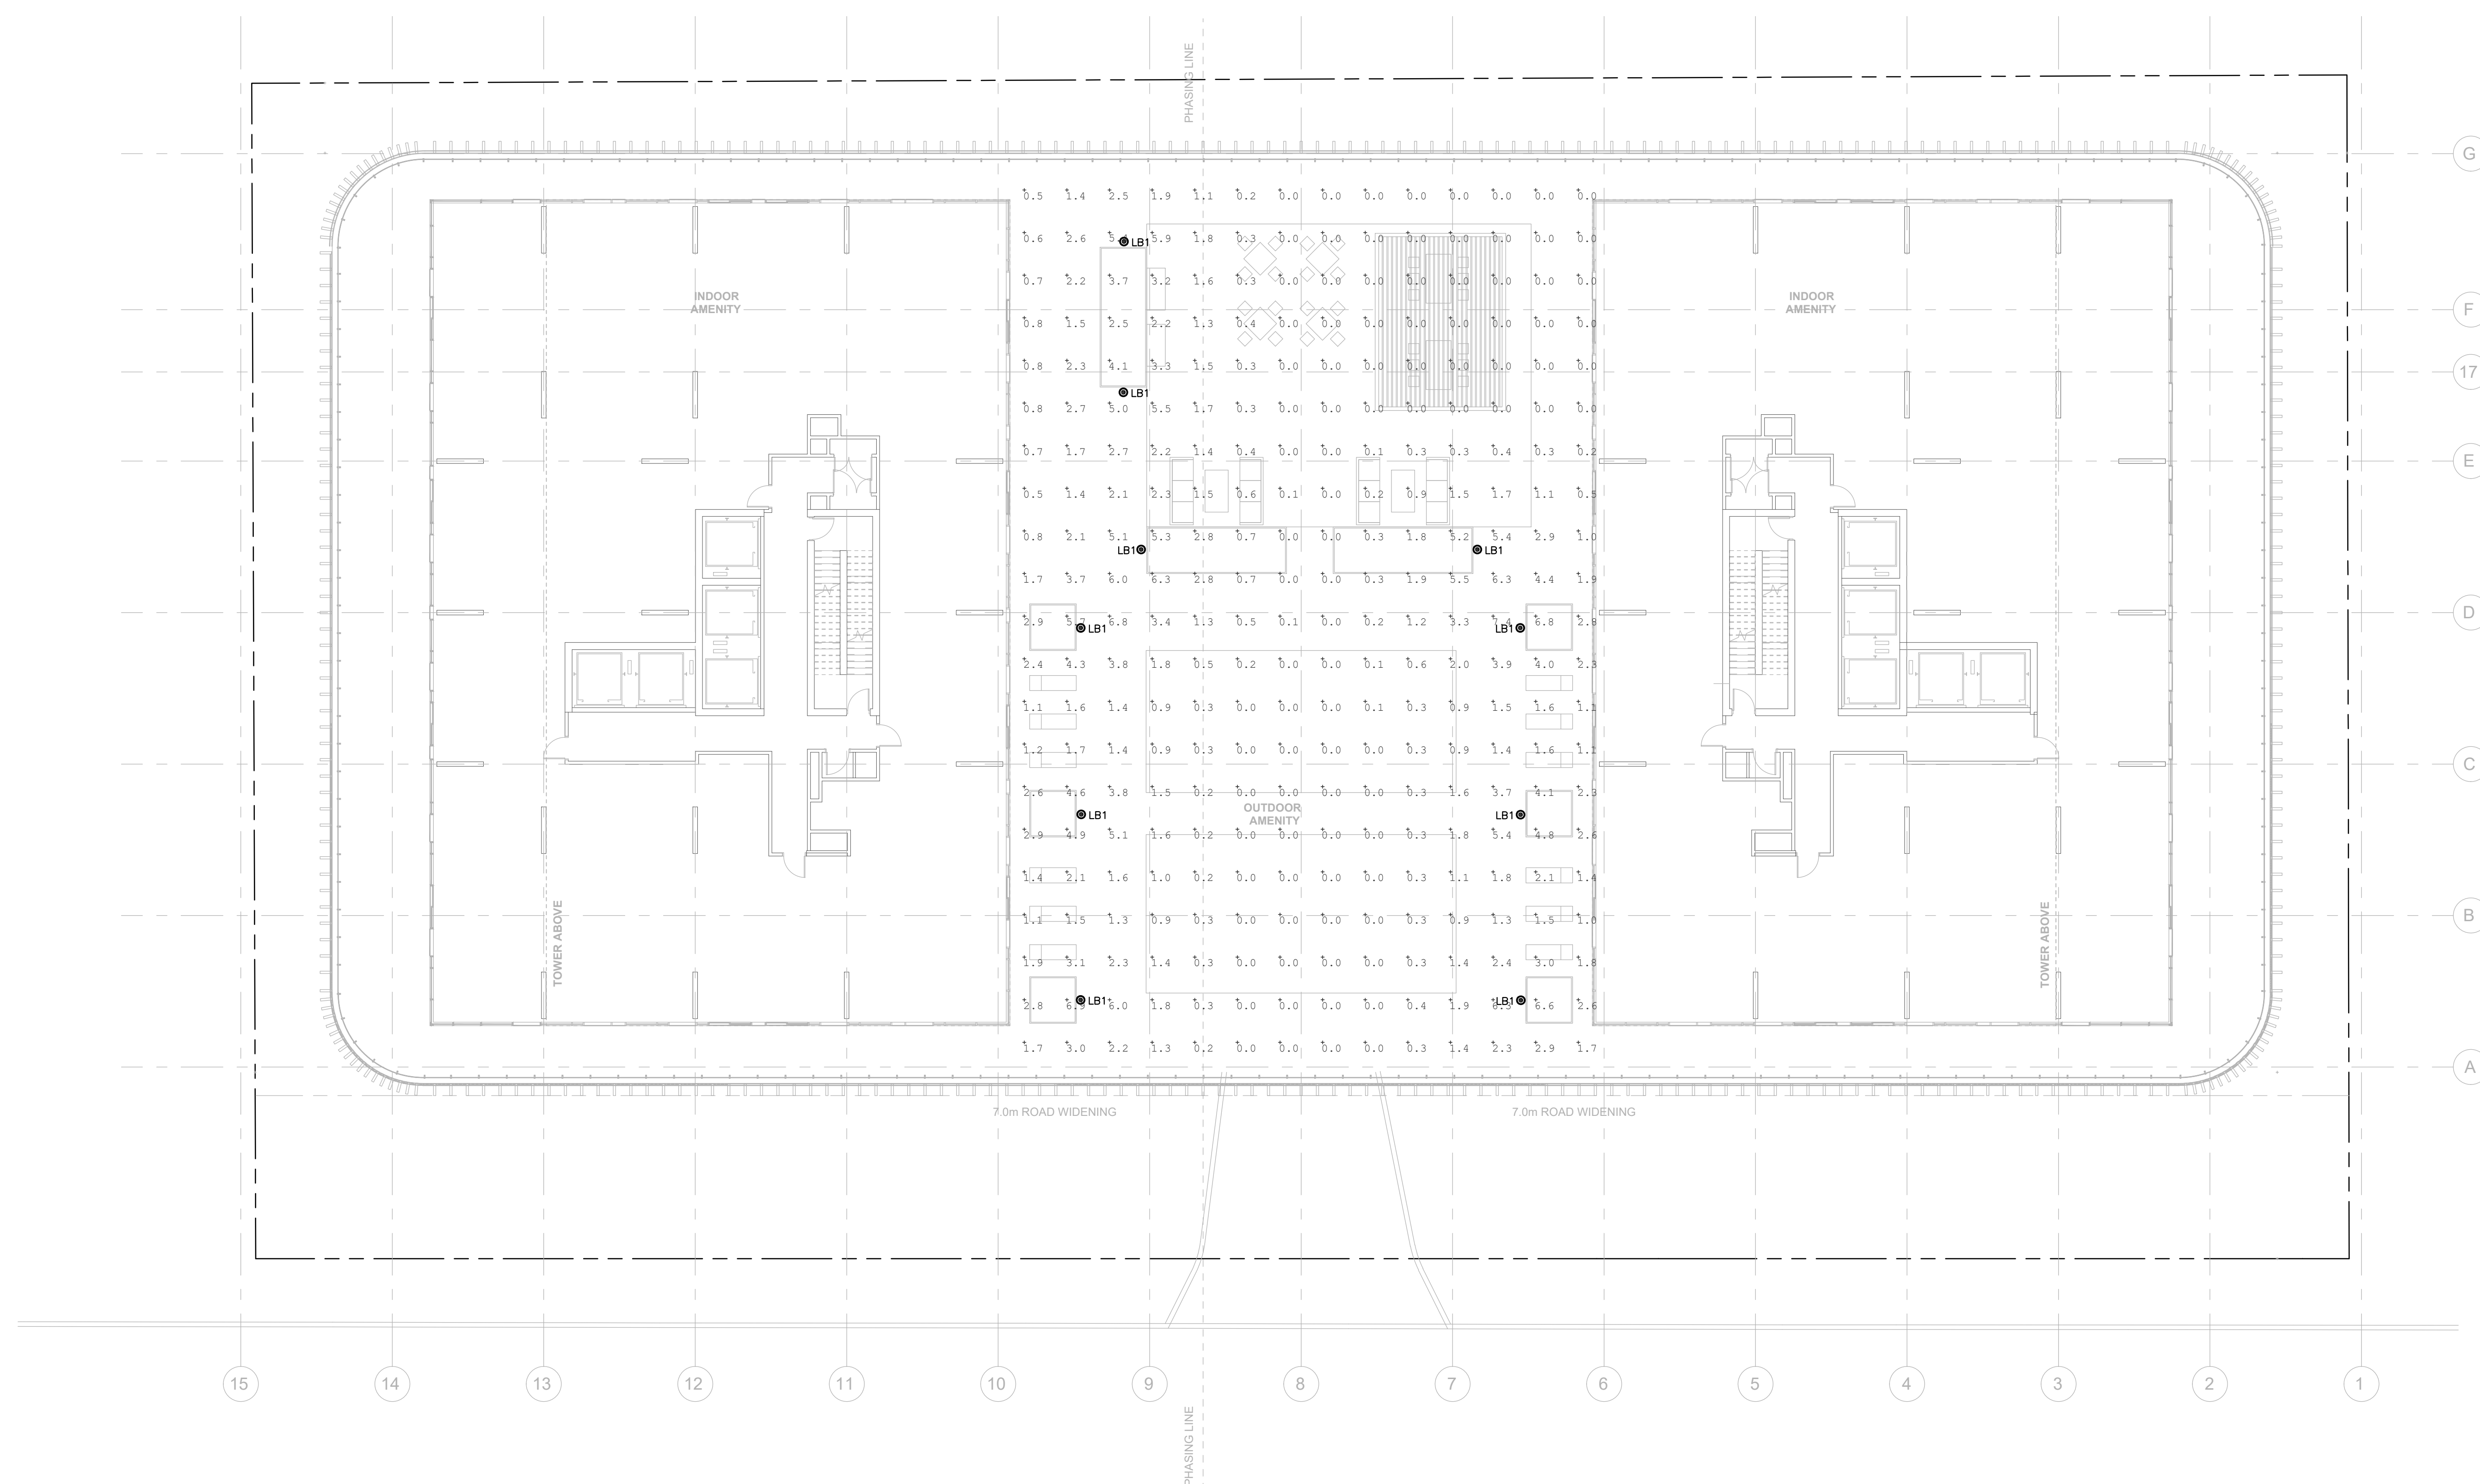

Schedule								
Symbol	Label	Arrangement	Lumen	Wattage	LLF	Mounting Height	Manufacturer	Equal Manufacturer
○	D1	SINGLE	938	10.05	0.9	4.88M 16"	ELITE: HH4-LED-900L-MD-30K-90 HH4-4501-CL-WH	STANPRO: CDU4R-G2
○	D2	SINGLE	600	7	0.9	2.75M 9"	ELITE: HH4-LED-600L-MD-30K-90 HH4-4501-CL-WH	STANPRO: CDU4R-G2
Ω	W1	SINGLE	1050	20	0.9	1.83M 6' FROM CENTRE	OCL: NP1-010A-18-LED1	TRIUMPH LIGHTING: WS-F-18"

CALCULATION SUMMARY							
LABEL	CALC TYPE	UNITS	AVG	MAX	MIN	AVG/MIN	MAX/MIN
GROUND PLANAR	ILLUMINANCE	FC	1.07	12.2	0.0	N.A.	N.A.
SPILL LIGHT	ILLUMINANCE	FC	0.04	0.3	0.0	N.A.	N.A.

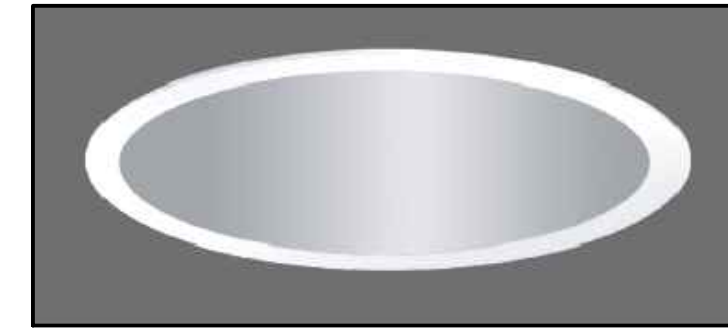

1 LUMINAIRE SCHEDULE AND DETAILS - SITE PLAN
E1.02 SCALE: N.T.S.

2 LUMINAIRE TYPE W1
E1.02 SCALE: N.T.S.

3 LUMINAIRE TYPE D1/D2
E1.02 SCALE: N.T.S.


Schedule								
Symbol	Label	Arrangement	Lumen	Wattage	LLF	Mounting Height	Manufacturer	Equal Manufacturer
●	LB1	SINGLE	1758	17.7	0.9	1.53M 5'	SIGNIFY: PBL-14L-350-NW-G2-5	STANPRO: MAR SERIES

CALCULATION SUMMARY							
LABEL	CALC TYPE	UNITS	AVG	MAX	MIN	AVG/MIN	MAX/MIN
AMENITY LEVEL	ILLUMINANCE	FC	1.40	7.4	0.0	N.A.	N.A.



4 LUMINAIRE SCHEDULE AND DETAILS - LEVEL 7 AMENITY
E1.02 SCALE: N.T.S.

5 LUMINAIRE TYPE LB1
E1.02 SCALE: N.T.S.

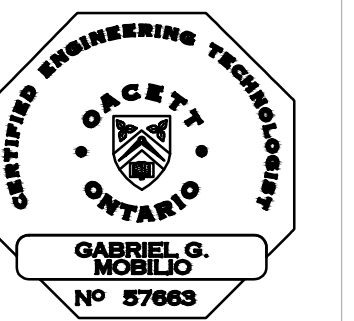

Do not scale the drawings.
This Drawing is Not To Be Used For Construction Until Signed By The Architect.

Date:

Revisions:		
No.	Revision	Date


1	ISSUED FOR SPA	NOV 13, 2023
---	----------------	--------------

Client:
Crown Communities Developments Inc.

126 Bradford St, Barrie, ON L4N 3B3
Proposed Residential Development

Drawing Title:
Lighting Details

Scale:
AS SHOWN
Drawn by:
F.C.
Checked by:
F.C.
Project No.:
23-166
Date:
NOV 28, 2023
Drawing No.:

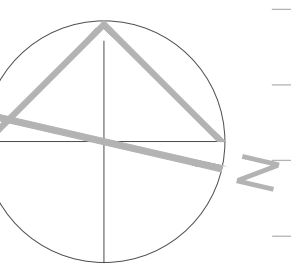

E1.04