



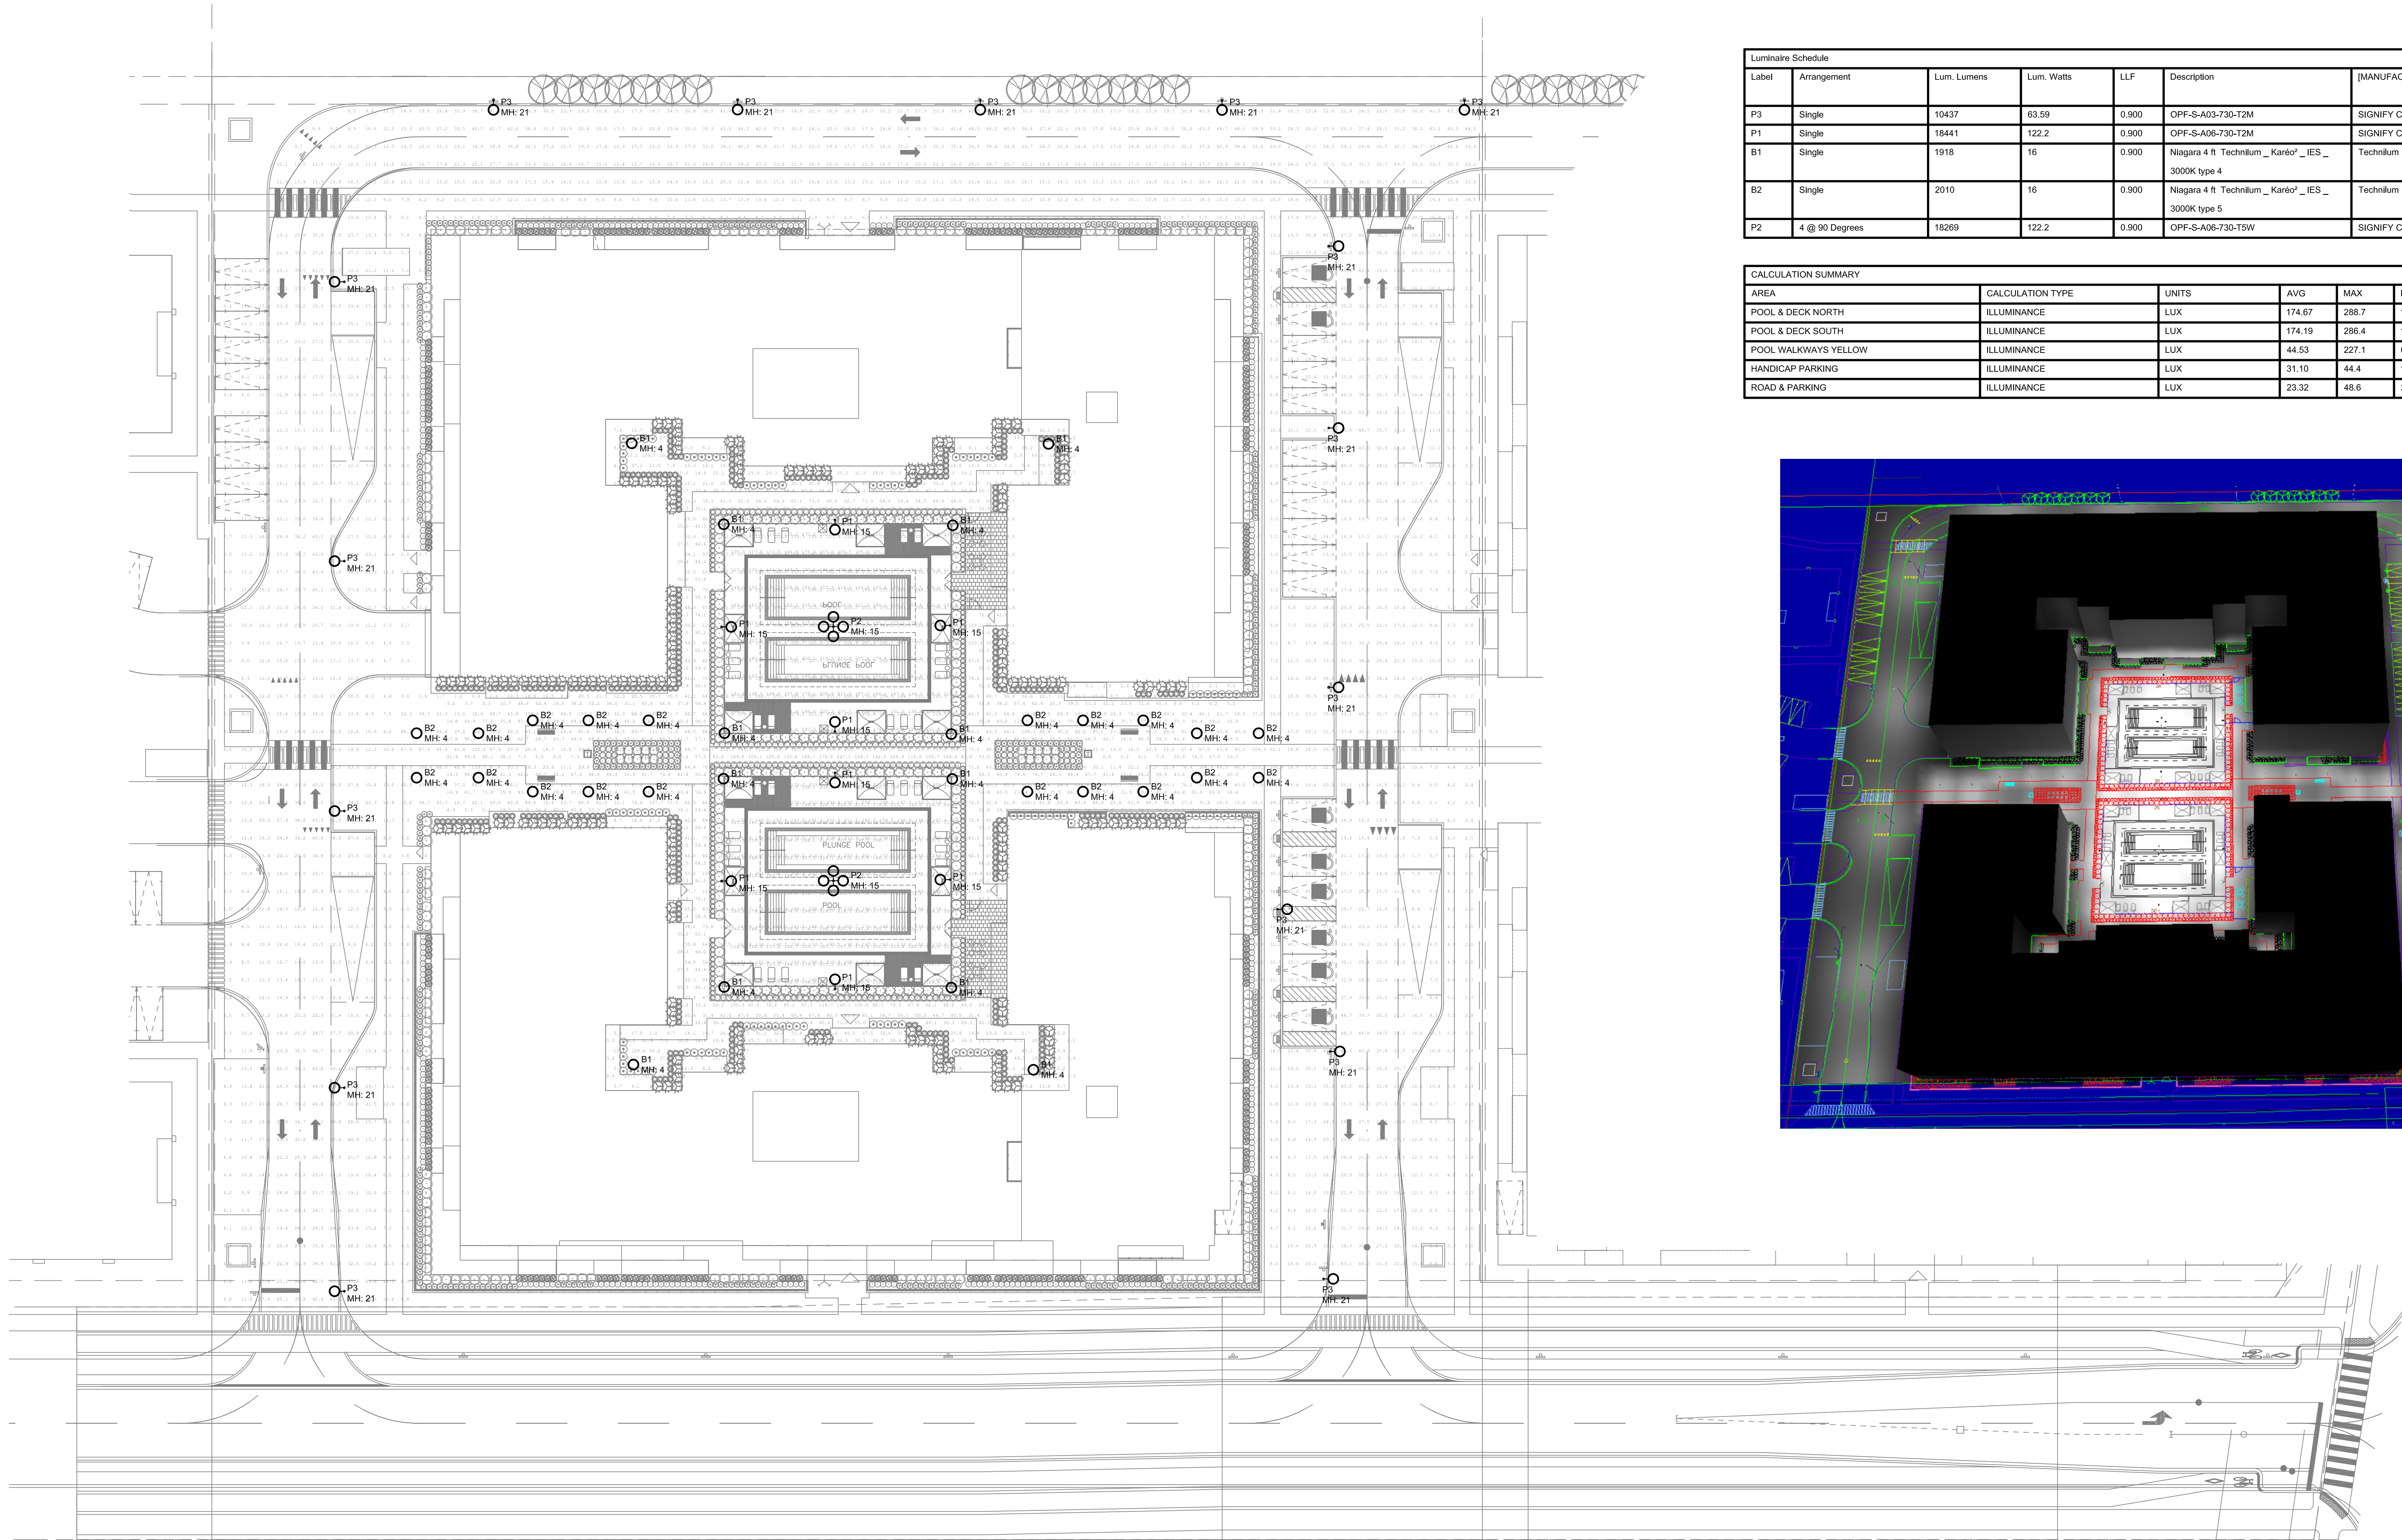

Luminaire Schedule						
Label	Arrangement	Lum. Lumens	Lum. Watts	LLF	Description	[MANUFAC] Mounting Height
P3	Single	10437	63.59	0.900	OPF-S-A03-730-T2M	SIGNIFY CANADA LTD 21
P1	Single	18441	122.2	0.900	OPF-S-A06-730-T2M	SIGNIFY CANADA LTD 15
B1	Single	1918	16	0.900	Niagara 4 ft. Technilum _ Karlo' _ IES _ 3000K type 4	Technilum 4
B2	Single	2010	16	0.900	Niagara 4 ft. Technilum _ Karlo' _ IES _ 3000K type 5	Technilum 4
P2	4 @ 90 Degrees	18269	122.2	0.900	OPF-S-A06-730-T5W	SIGNIFY CANADA LTD 15

CALCULATION SUMMARY							
AREA	CALCULATION TYPE	UNITS	AVG	MAX	MIN	AVG MIN	MAX MIN
POOL & DECK SOUTH	ILLUMINANCE	LUX	174.67	288.7	107.7	1.62	2.68
POOL & DECK NORTH	ILLUMINANCE	LUX	174.19	286.4	102.1	1.71	2.81
POOL WALKWAYS YELLOW	ILLUMINANCE	LUX	44.53	227.1	0.1	445.30	2271
HANDICAP PARKING	ILLUMINANCE	LUX	31.10	44.4	16.6	1.85	2.64
ROAD & PARKING	ILLUMINANCE	LUX	23.32	46.6	2.3	10.14	21.13

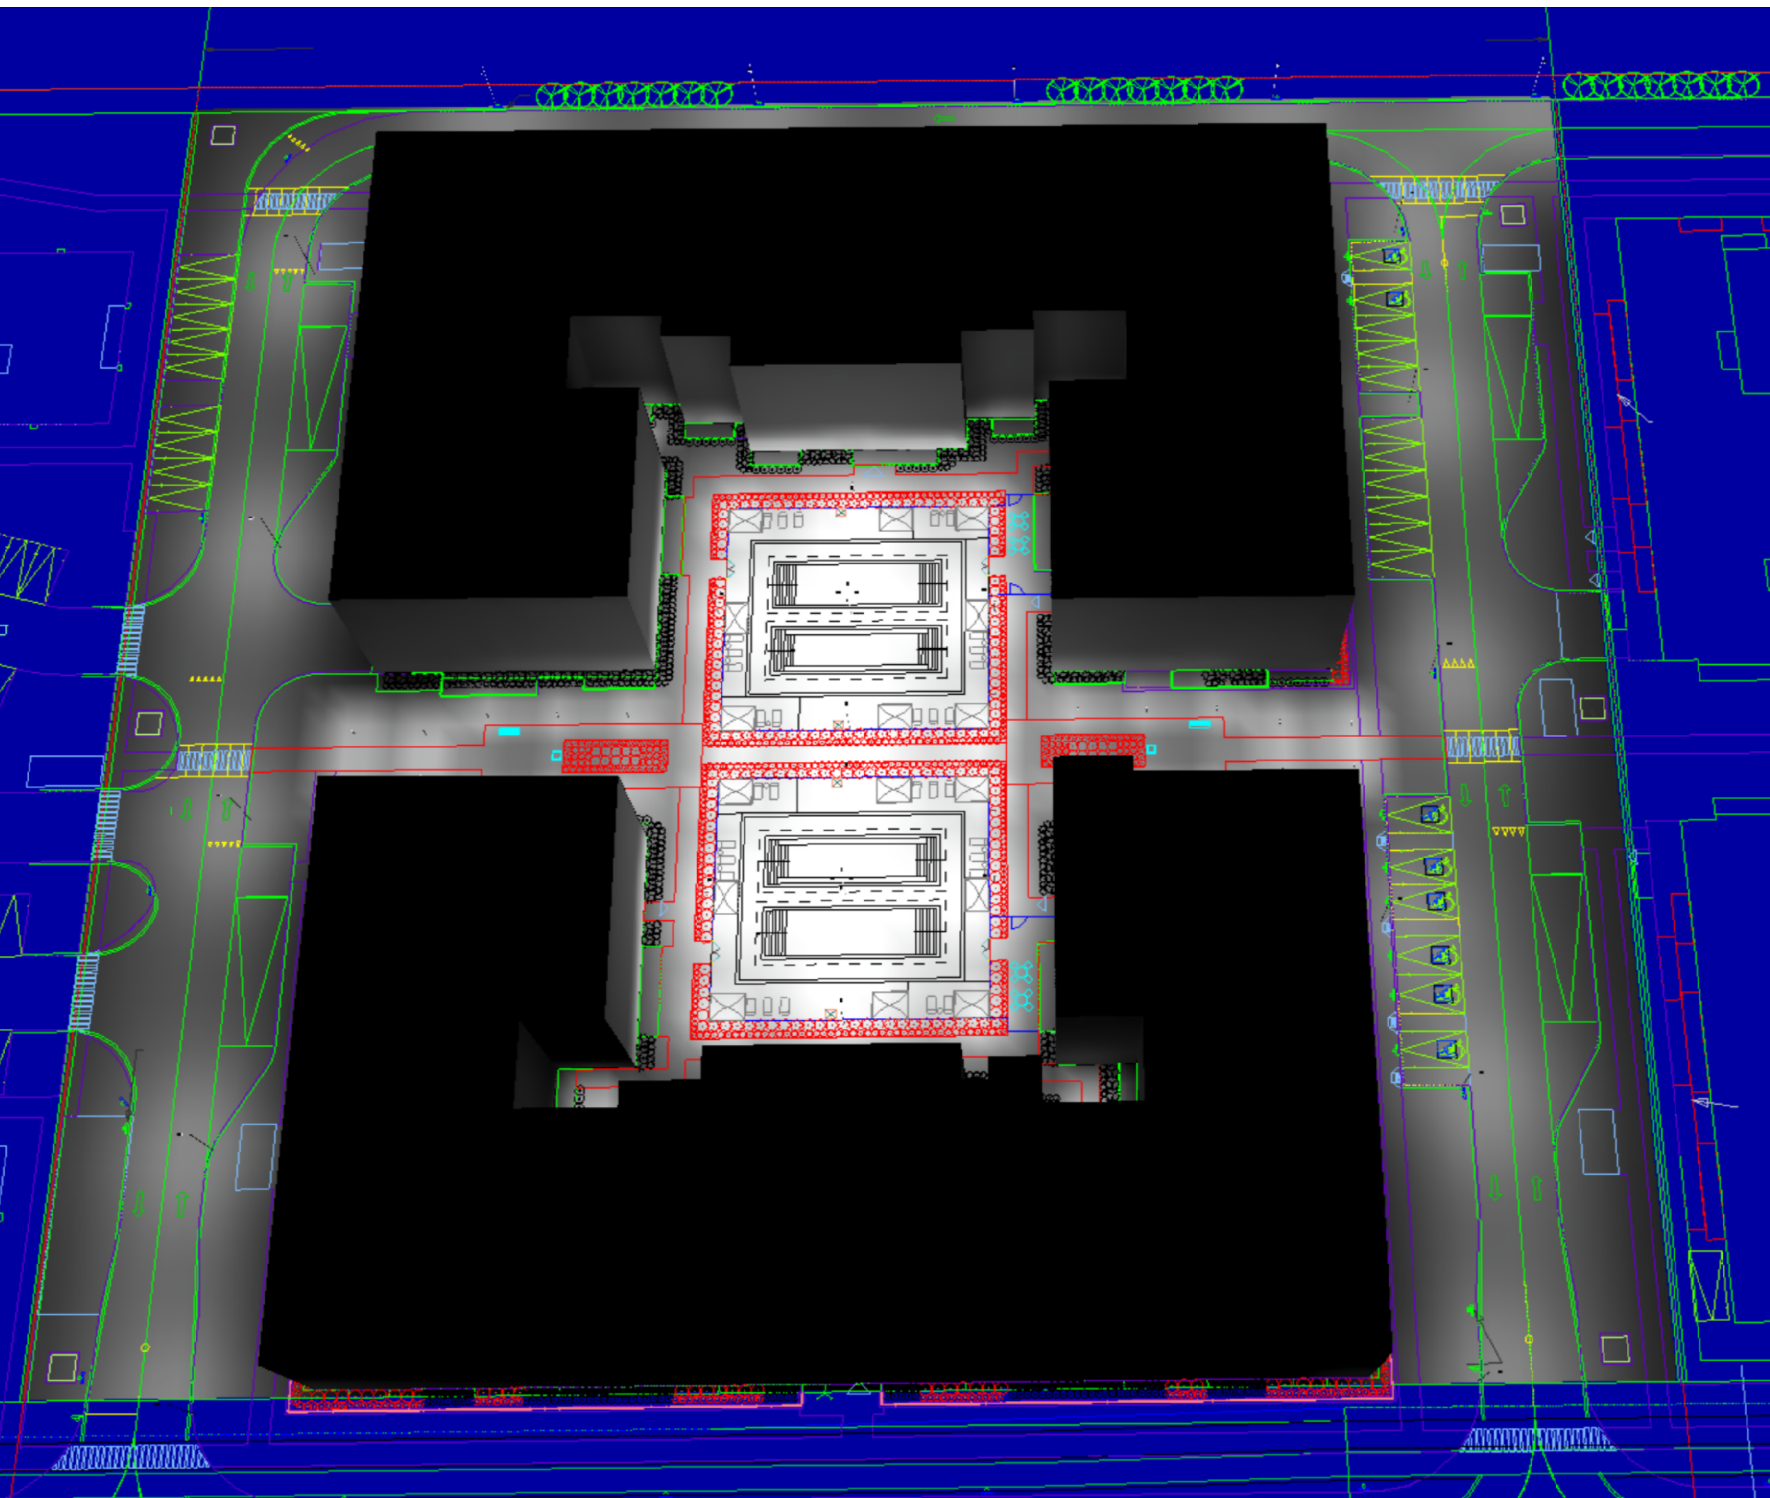

SEAL:

PRELIMINARY
THIS DRAWING IS FOR
PROGRESS DOCUMENTATION
ONLY AND IS NOT FOR
CONSTRUCTION PURPOSES

PERMIT:

KEY PLAN:



1	ISSUED FOR SPA	2024-07-12
No.	Issuance	Date
CROWN (BARRIE) DEVELOPMENTS INC.		
1012 YONGE STREET		
PROJECT NO:	24223-01	DRAWN:
SCALE:	1:350	RL
ISSUED:	2024-07-12	SB

SHEET NAME:

ELECTRICAL SITE PLAN

SHEET NUMBER:

E1-101