


- NOTES:
- ALL UNITS ARE IN LUX. POINT SPACING IS 1.5M X 1.5M.
 - PHOTOMETRIC CALCULATIONS SHOW ZERO LIGHT TRESPASS INTO MTO RIGHT OF WAY ON HIGHWAY 400.

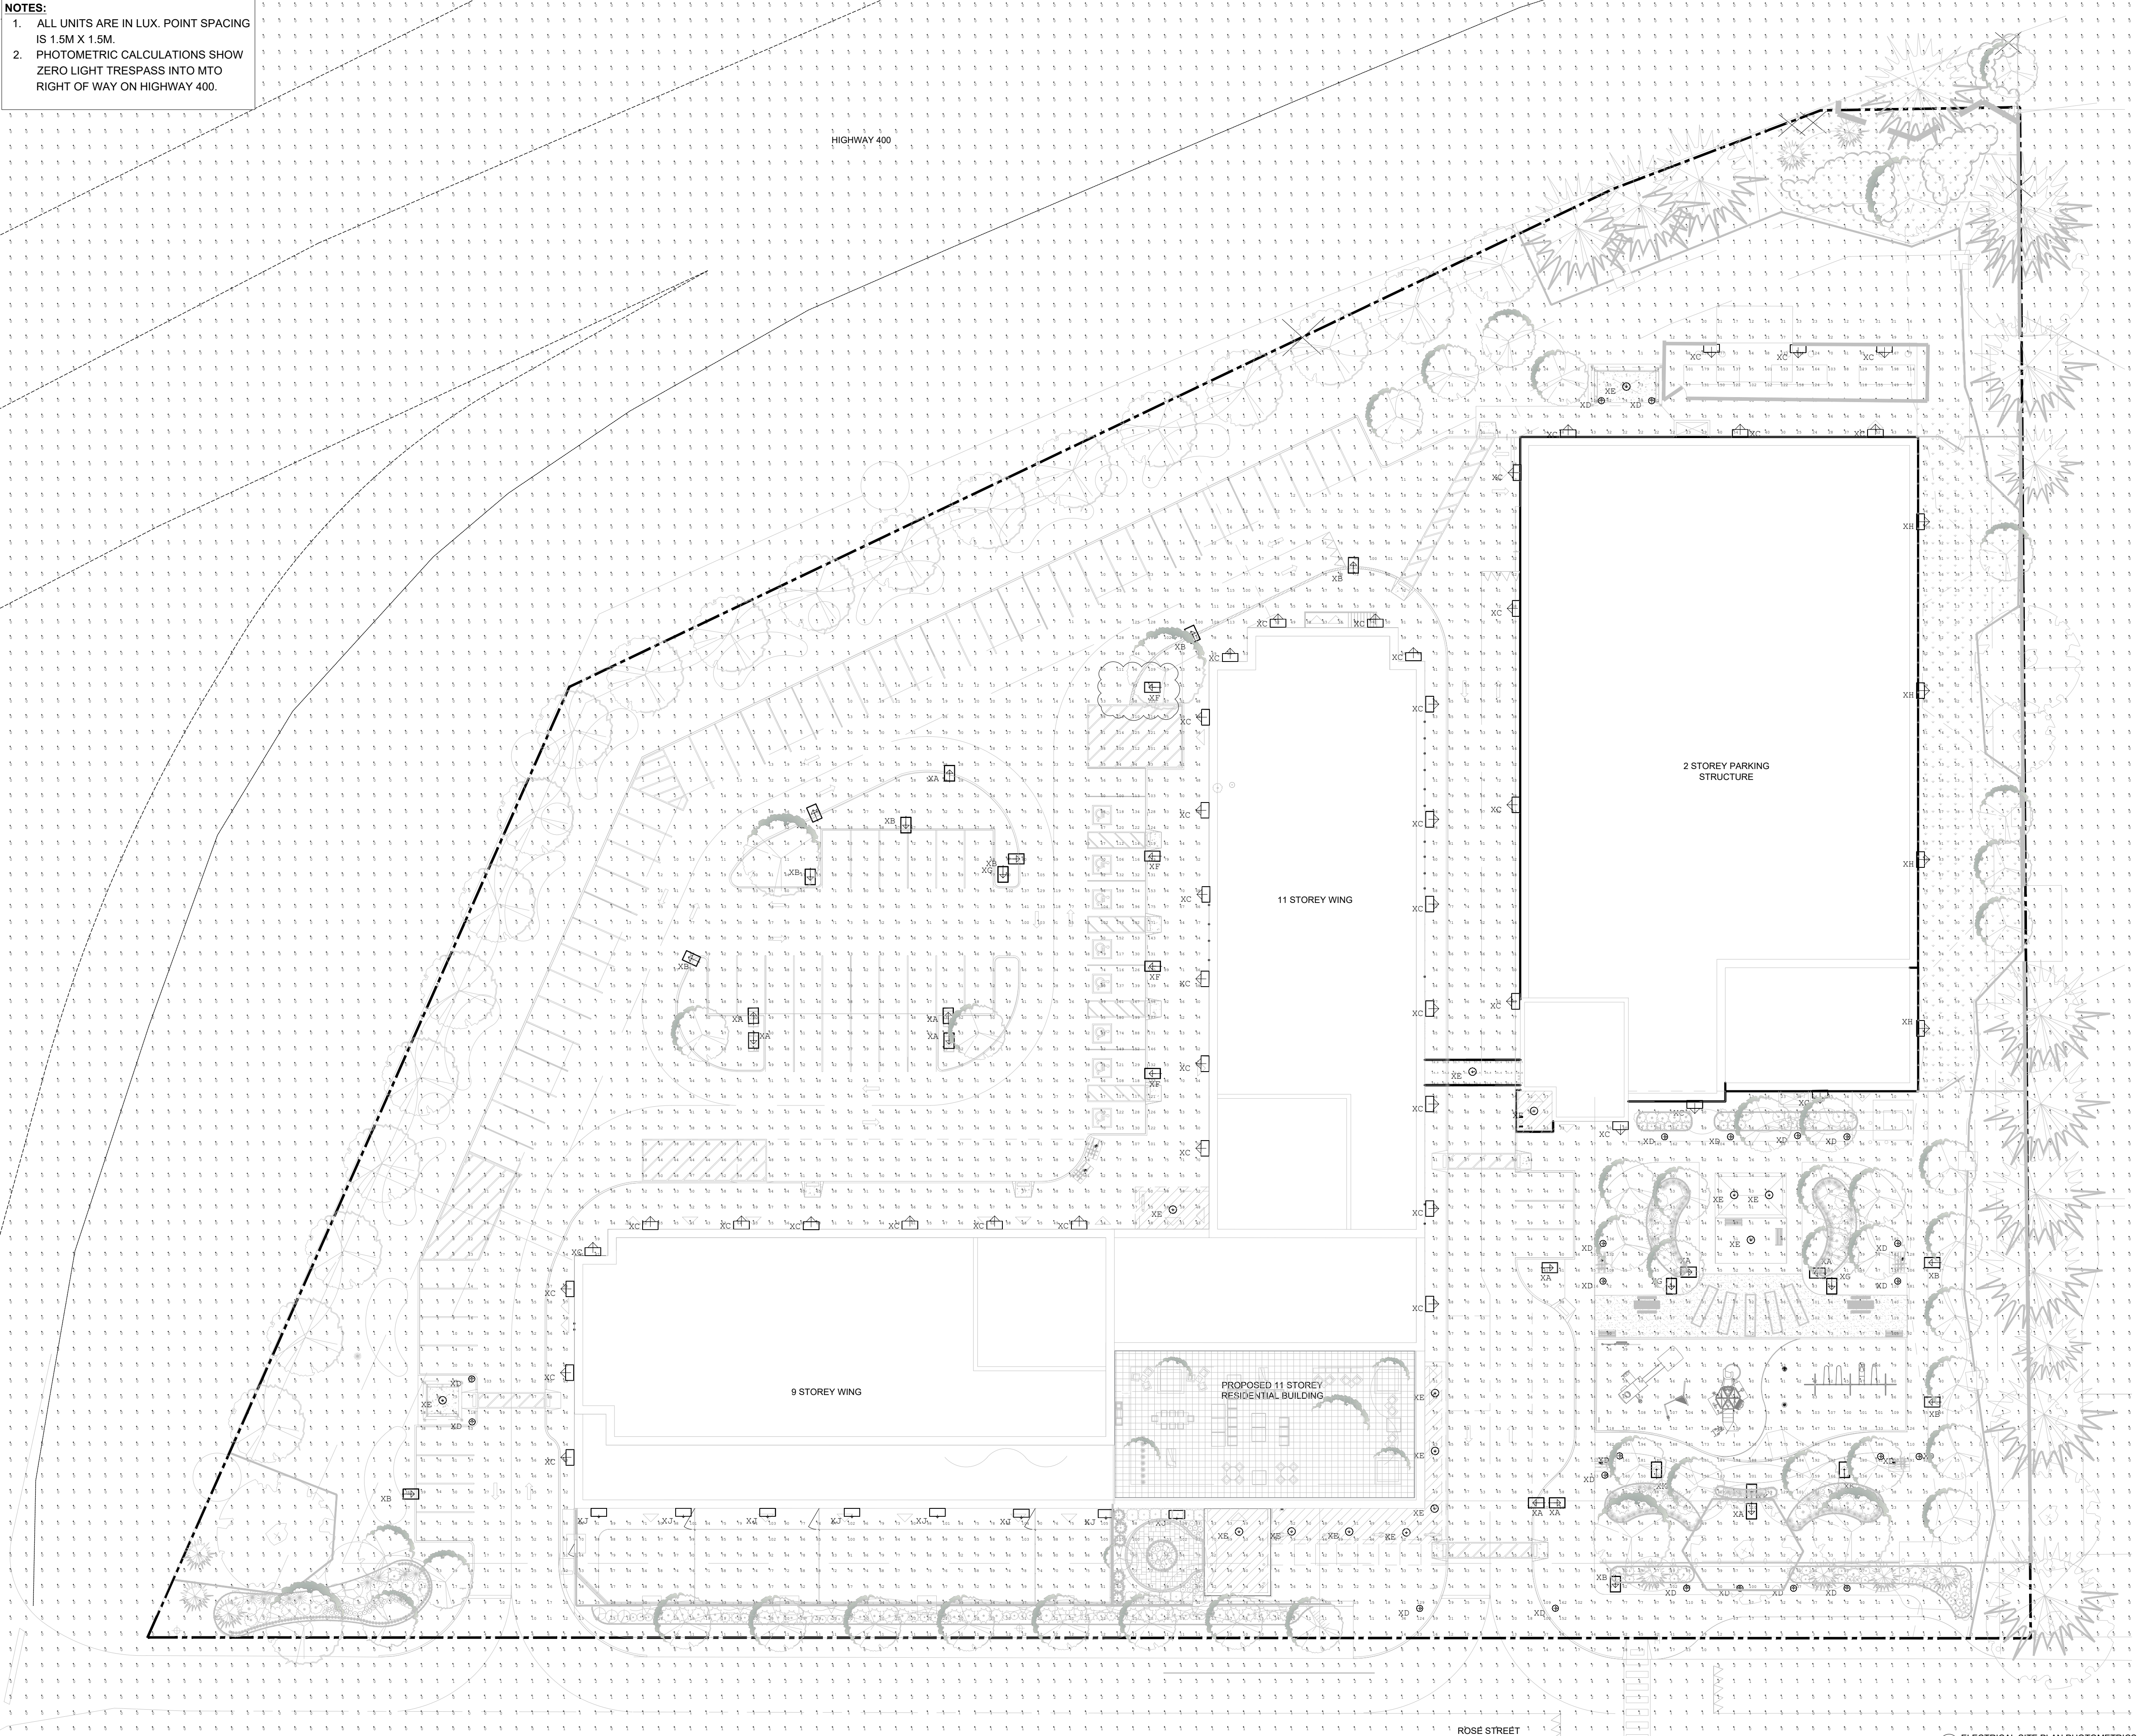

Gerrits
ENGINEERING

222 Mapleview Drive West, Suite 300
Barrie, ON L4N 9E7 Canada
Tel.: 705.737.3303
Fax.: 705.737.1772
www.gerrits.com

This drawing has been created electronically.

Handwritten or manual revisions to the drawing are only valid when accompanied by the design engineer's initials.

Do not scale drawings.
Check and verify all dimensions and information on the drawings and report all errors or omissions to the Consultant before proceeding with the work. This drawing shall not be reproduced in any manner, in part or in whole, for any project other than that for which it was prepared. This drawing, and all design concepts it contains, are an instrument of professional service and remain the property of Gerrits Engineering.

This drawing may have been reduced.

0 5 10 20 30 40 50mm
0" 1/4" 1/2" 1" 1 1/2" 2"

No.	Issuance Description	YYMMDD
1.	RE-ISSUED FOR SITE PLAN APPROVAL	24/04/26
2.	RE-ISSUED FOR SITE PLAN APPROVAL	24/05/24
3.	ISSUED FOR COORDINATION	24/06/21
4.	RE-ISSUED FOR SITE PLAN APPROVAL	24/06/24
5.	ISSUED FOR COORDINATION	24/07/26
6.	ISSUED FOR COORDINATION	24/08/23
7.	ISSUED FOR SITE PLAN APPROVAL	24/09/11

ISSUED FOR:

SITE PLAN APPROVAL

DRAWINGS ARE 'ISSUED FOR SITE PLAN APPROVAL' AND ARE NOT TO BE USED FOR PERMIT APPLICATIONS OR CONSTRUCTION UNTIL SO AUTHORIZED BY THE CONSULTANT.

Client

MCL ARCHITECTS

Project

ROSE STREET AFFORDABLE HOUSING

20 Rose Street, Barrie, ON

Drawing:

ELECTRICAL SITE PLAN -
PHOTOMETRICS

Project No.



176-014-23

Time Stamp:

Designed by: MG Checked by: CP

Orientation

Drawn by: CC/MG Approved by: CP

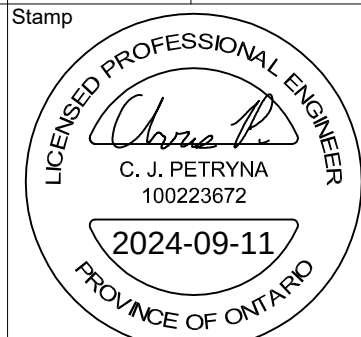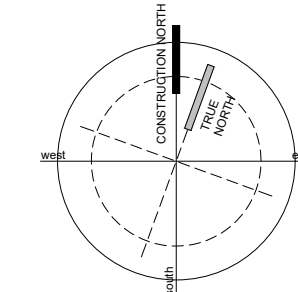


Drawing No.

E-100

1 ELECTRICAL SITE PLAN PHOTOMETRICS
SCALE: 1:300

- NOTES:
1. ASSUME MOUNTING HEIGHT IS FROM "LEVEL 1" UNLESS OTHERWISE STATED.
 2. REFER TO STRUCTURAL FOR LIGHT STANDARD AND BOLLARD BASE DETAIL.

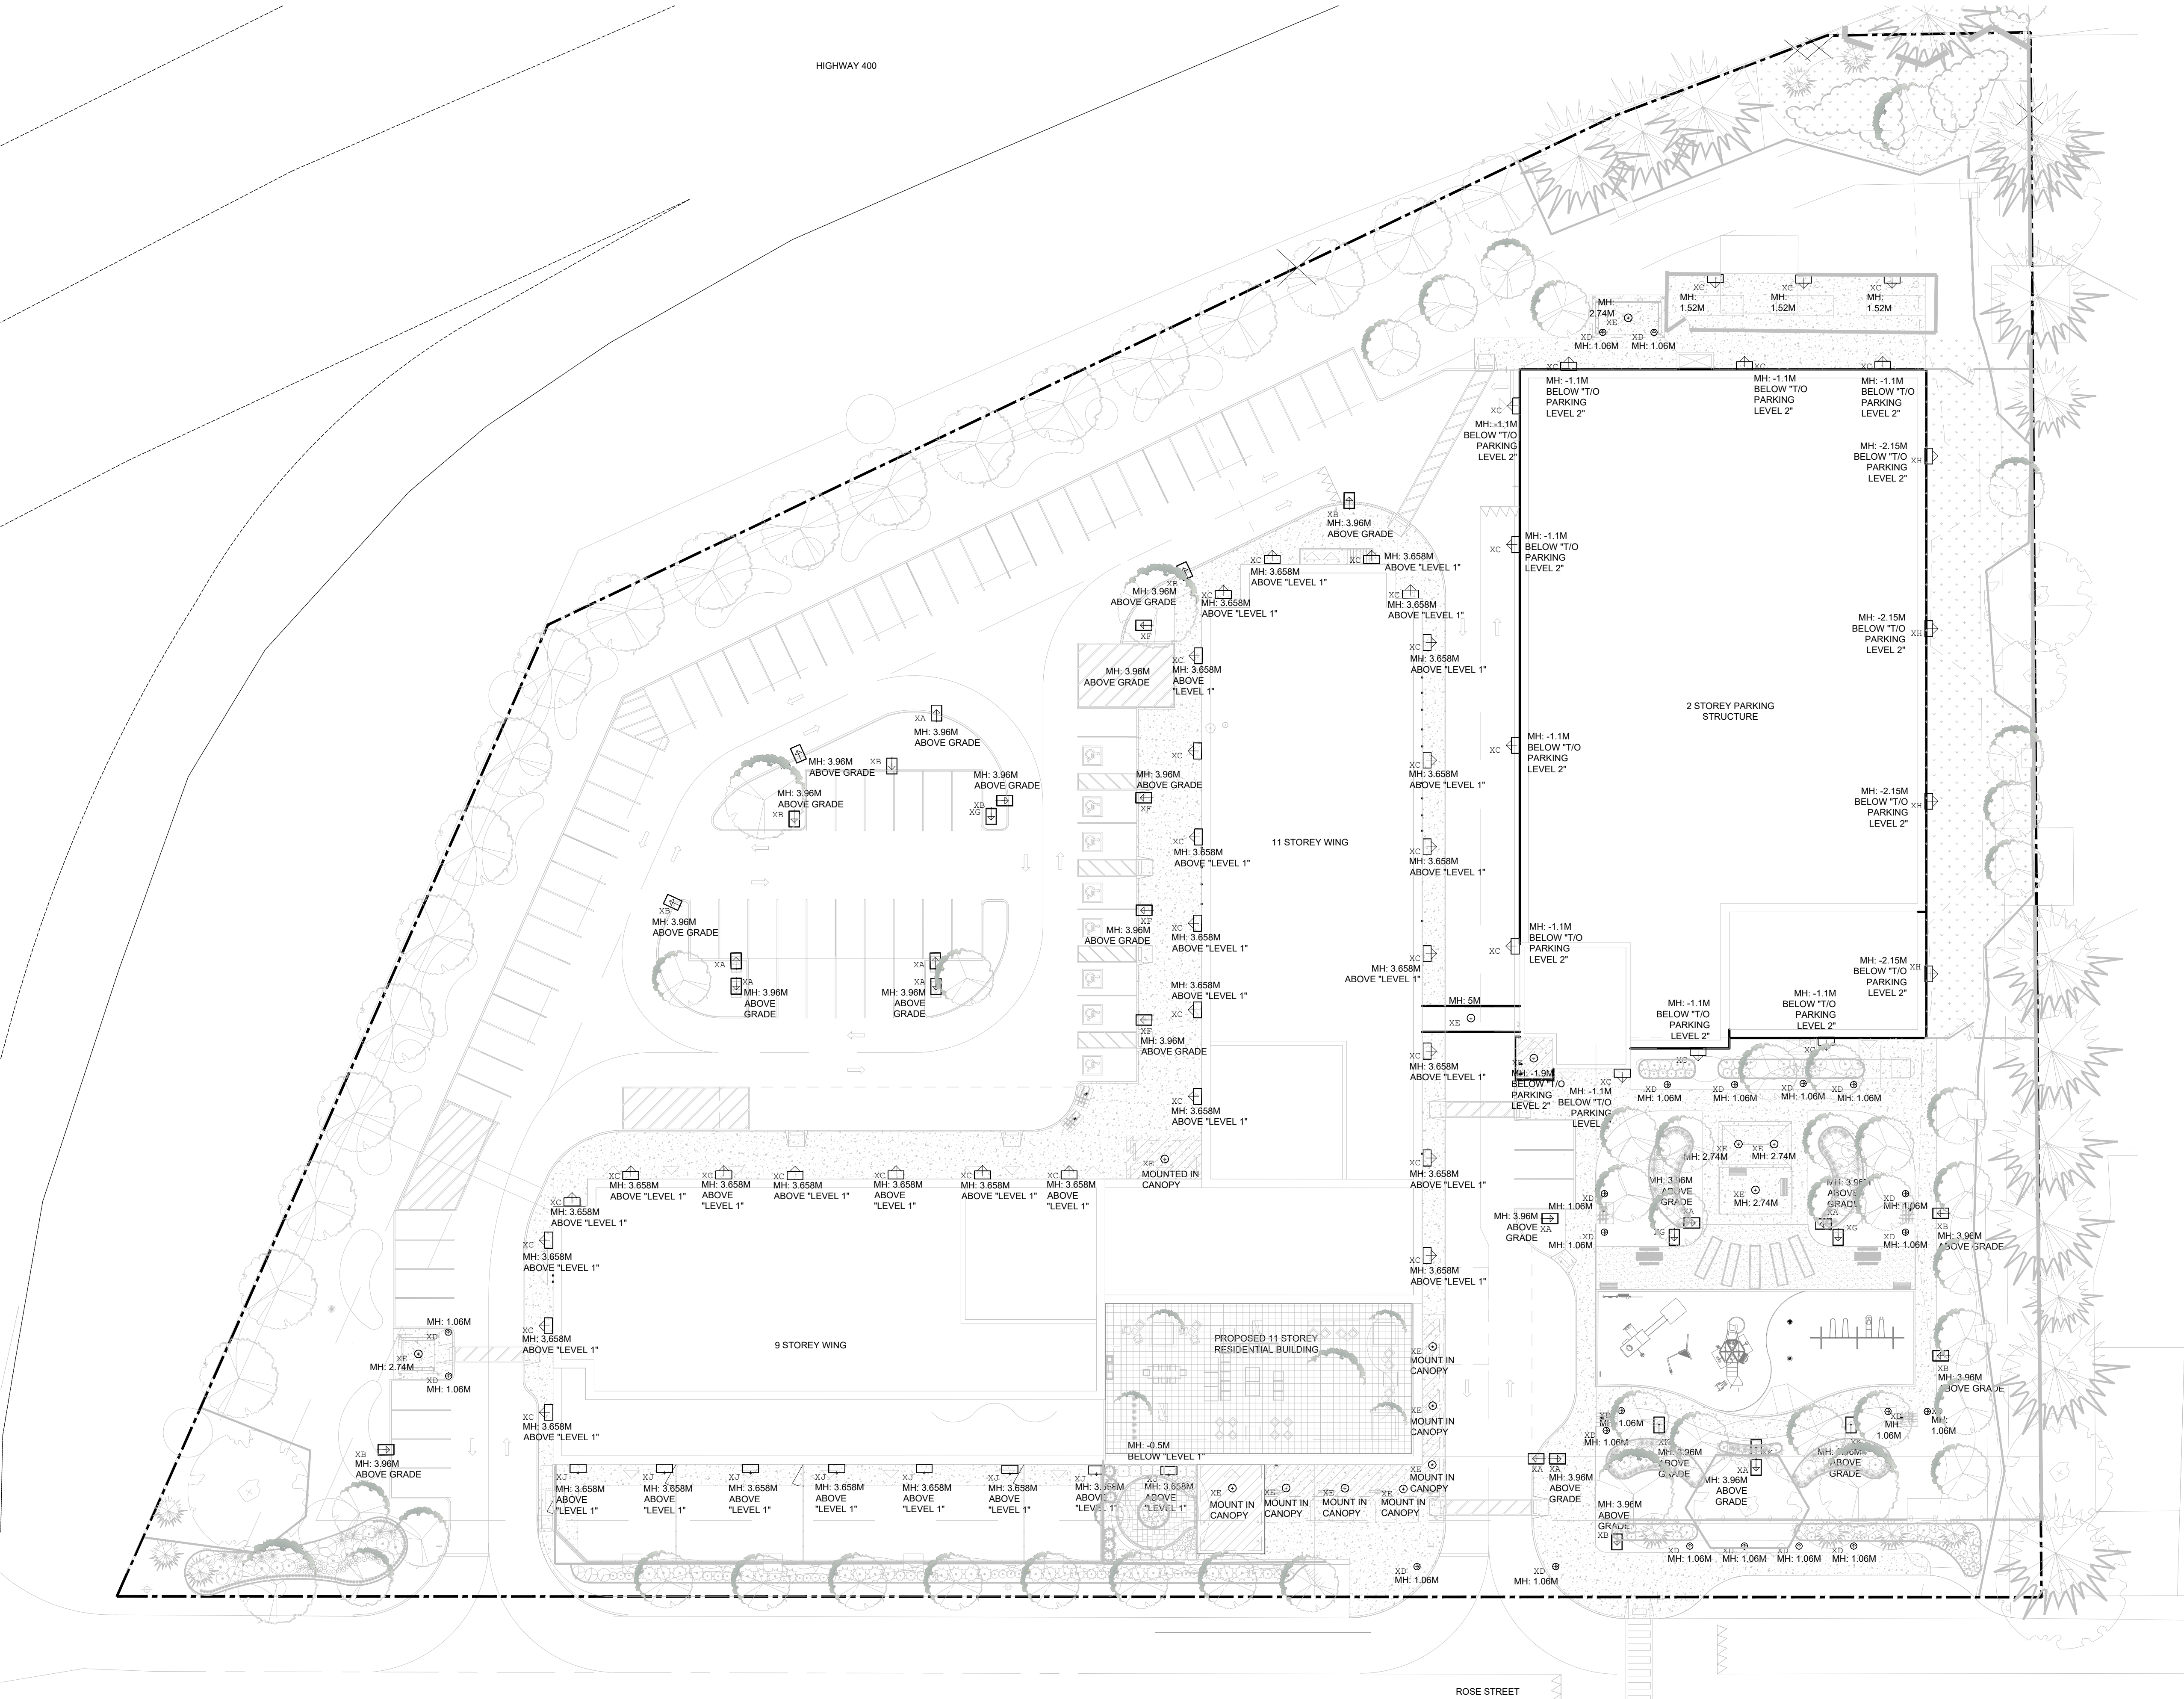

Gerrits
ENGINEERING

222 Mapleview Drive West, Suite 300
Barrie, ON L4N 9E7 Canada
Tel.: 705.737.3303
Fax.: 705.737.1772
www.gerrits.com

This drawing has been created electronically.

Handwritten or manual revisions to the drawing are only valid when accompanied by the design engineer's initials.

Do not scale drawings.
Check and verify all dimensions and information on the drawings and report all errors or omissions to the Consultant before proceeding with the work. This drawing shall not be reproduced in any manner, in part or in whole, for any project other than that for which it was prepared. This drawing, and all design concepts it contains, are an instrument of professional service and remain the property of Gerrits Engineering.

This drawing may have been reduced.

0 5 10 20 30 40 50mm
0" 1/4" 1/2" 1" 1 1/2" 2"

No.	Issuance Description	YYMMDD
1.	RE-ISSUED FOR SITE PLAN APPROVAL	24/04/26
2.	RE-ISSUED FOR SITE PLAN APPROVAL	24/05/24
3.	ISSUED FOR COORDINATION	24/06/21
4.	RE-ISSUED FOR SITE PLAN APPROVAL	24/06/24
5.	ISSUED FOR COORDINATION	24/07/26
6.	ISSUED FOR COORDINATION	24/08/23
7.	ISSUED FOR SITE PLAN APPROVAL	24/09/11

ISSUED FOR:

SITE PLAN APPROVAL

DRAWINGS ARE "ISSUED FOR SITE PLAN APPROVAL" AND ARE NOT TO BE USED FOR PERMIT APPLICATIONS OR CONSTRUCTION UNTIL SO AUTHORIZED BY THE CONSULTANT.

Client

MCL ARCHITECTS

Project

ROSE STREET AFFORDABLE HOUSING

20 Rose Street, Barrie, ON


Drawing:

ELECTRICAL SITE PLAN - LIGHTING

Project No. 176-014-23 Designed by: MG Checked by: CP

Time Stamp: Drawn by: CC/MG Approved by: CP

Orientation

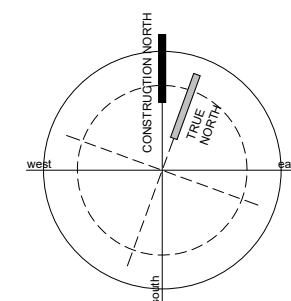


Drawing No.

E-101

1 ELECTRICAL SITE PLAN
SCALE 1:300

WIRE TYPE LEGEND	
COMMUNICATIONS LINE	COM
UNDERGROUND HYDRO PRIMARY	UGP
OVERHEAD HYDRO PRIMARY	OSP
UNDERGROUND HYDRO SECONDARY	UGS
GENERATOR DISCHARGE	GD
GENERATOR INTAKE	GI

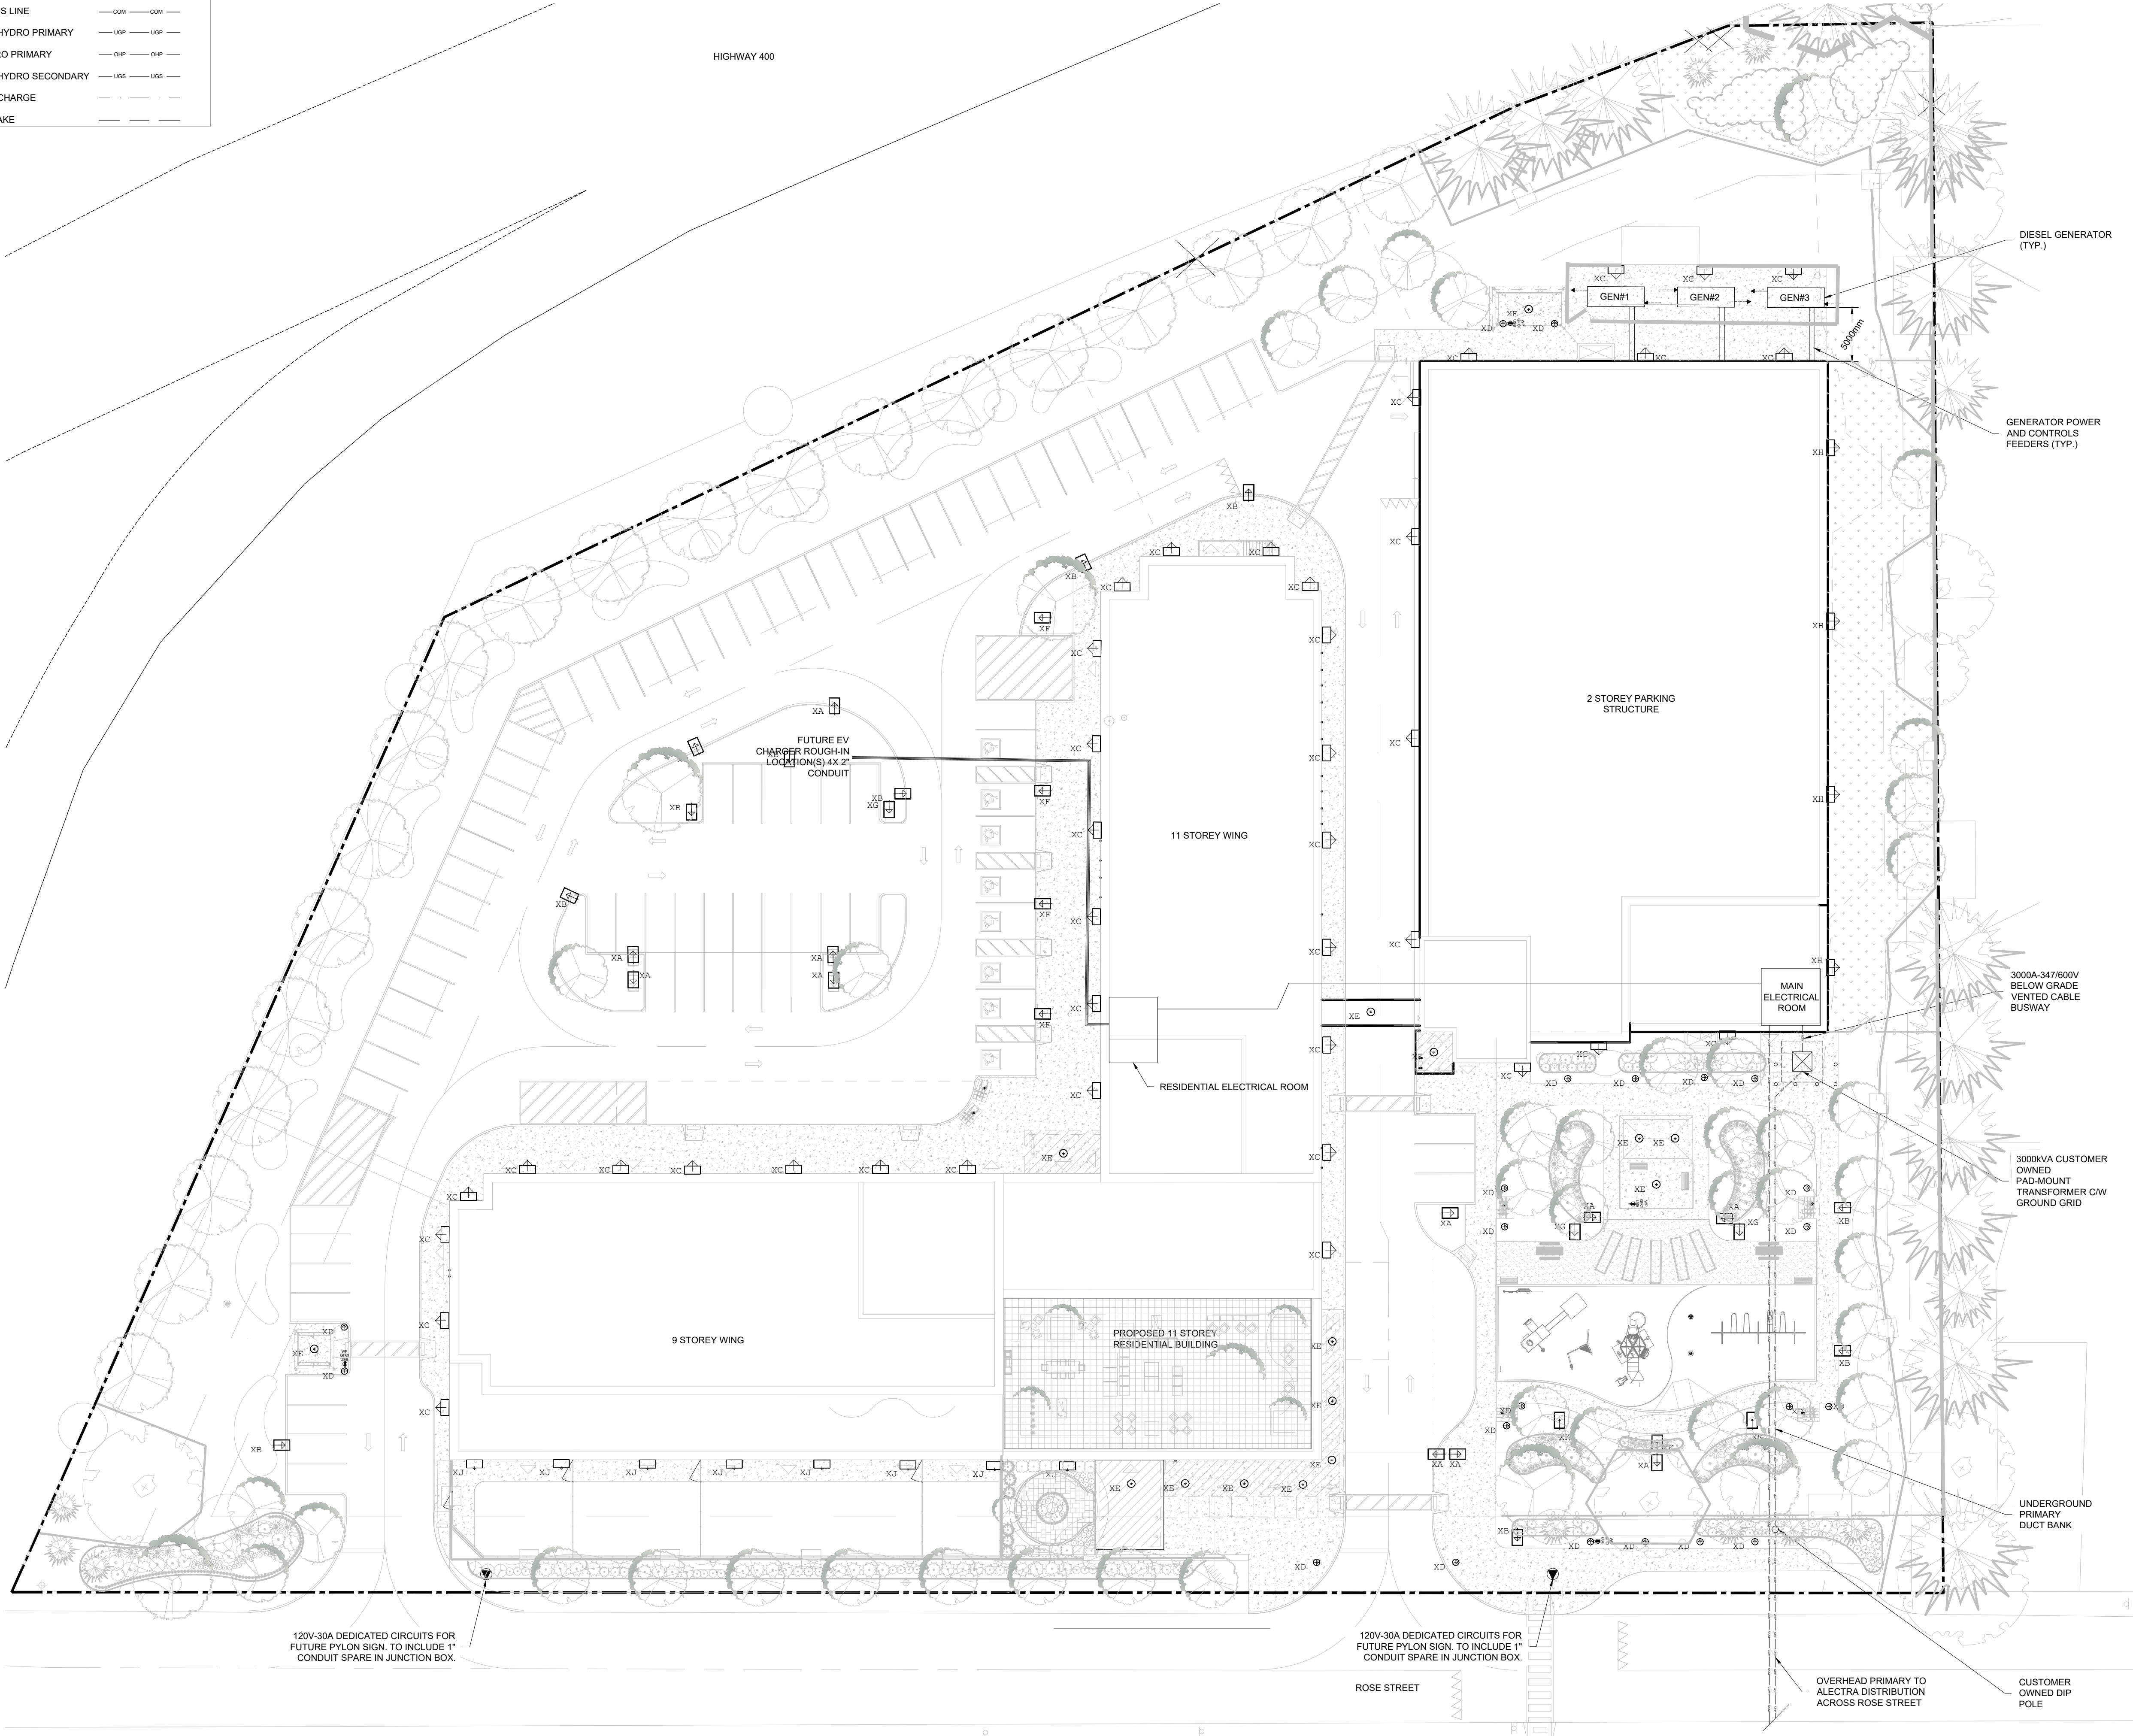

Gerrits
ENGINEERING

 
222 Mapleview Drive West, Suite 300
Barrie, ON L4N 9E7 Canada
Tel.: 705.737.3303
Fax.: 705.737.1772
www.gerrits.com

This drawing has been created electronically.

Handwritten or manual revisions to the drawing are only valid when accompanied by the design engineer's initials.

Do not scale drawings.
Check and verify all dimensions and information on the drawings and report all errors or omissions to the Consultant before proceeding with the work. This drawing shall not be reproduced in any manner, in part or in whole, for any project other than that for which it was prepared. This drawing, and all design concepts it contains, are an instrument of professional service and remain the property of Gerrits Engineering.

This drawing may have been reduced.



No.	Issuance Description	YYMMDD
1.	RE-ISSUED FOR SITE PLAN APPROVAL	24/04/26
2.	RE-ISSUED FOR SITE PLAN APPROVAL	24/05/24
3.	ISSUED FOR COORDINATION	24/06/21
4.	RE-ISSUED FOR SITE PLAN APPROVAL	24/06/24
5.	ISSUED FOR COORDINATION	24/07/26
6.	ISSUED FOR COORDINATION	24/08/23
7.	ISSUED FOR SITE PLAN APPROVAL	24/09/11

ISSUED FOR:

SITE PLAN APPROVAL

DRAWINGS ARE 'ISSUED FOR SITE PLAN APPROVAL' AND ARE NOT TO BE USED FOR PERMIT APPLICATIONS OR CONSTRUCTION UNTIL SO AUTHORIZED BY THE CONSULTANT.

Client

MCL ARCHITECTS

Project

ROSE STREET AFFORDABLE HOUSING

20 Rose Street, Barrie, ON

Drawing:

ELECTRICAL SITE PLAN - POWER

Project No.


176-014-23

Time Stamp:

Designed by: MG Checked by: CP

Orientation

Drawn by: MG Approved by: CP

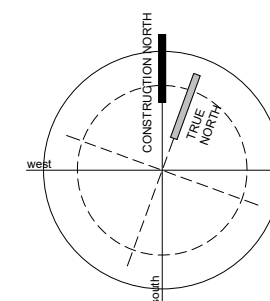

Drawing No.

E-102

1 ELECTRICAL SITE PLAN
SCALE 1:300

PHOTOMETRIC RESULTS :

Project Calculation
Illuminance (Lux)
Average=9.57 Maximum=224 Minimum=0 Avg/Min=N.A. Max/Min=N.A. Max/Avg=23.41


Stat Areas

OPEN AREA PARKING
Illuminance (Lux)
Average=40.81 Maximum=199.0 Minimum=0.0 Avg/Min=N.A. Max/Min=N.A. Max/Avg=4.88

PLAYGROUND
Illuminance (Lux)
Average=77.82 Maximum=215.0 Minimum=6.0 Avg/Min=12.99 Max/Min=35.83 Max/Avg=2.76


EXTERIOR LUMINAIRE SCHEDULE

SYMBOL	TYPE MARK	DESCRIPTION	MANUFACTURER	CATALOG NUMBER	LAMP(S)	SUPPLY VOLTAGE	WATTS
	XA	LIGHT STANDARD: TYPE 5 SQUARE DISTRIBUTION, 9,000 LUMENS, DLC LISTED, DARK SKY COMPLIANT, MOUNT FIXTURE AT 3.96m, BIRD SPIKES, BLACK FINISH. POLE: ALUMINUM, SQUARE, NON-TAPERED, 4\"/>	ILP	SAS-9L-U-40-TSS-SAS/BIRD	LED-4000K	120VAC	70W
	XB	LIGHT STANDARD: TYPE 3 DISTRIBUTION, 9,000 LUMENS, HOUSE SIDE SHIELD, DLC LISTED, DARK SKY COMPLIANT, MOUNT FIXTURE AT 3.96m, BIRD SPIKES, BLACK FINISH. POLE: ALUMINUM, SQUARE, NON-TAPERED, 4\"/>	ILP	SAS-9L-U-40-T3-HSS-SAS/BIRD	LED-4000K	120VAC	70W
	XC	WALL PACK: TYPE 4 DISTRIBUTION, 6,000 LUMENS, FULL CUTOFF, HIGH EFFICIENCY, DLC LISTED, DARK SKY COMPLIANT, BLACK FINISH.	ILP	WPCM-6L-U-40-T4	LED-4000K	120VAC	40W
	XD	BOLLARD: 1,200 LUMEN, FLAT TOP, HIGH EFFICIENCY, DLC LISTED, LISTED FOR WET LOCATIONS, MOUNT AT 1.1m ABOVE GRADE, BLACK FINISH.	ILP	BLDT-15WLED-UNIV-4000K	LED-4000K	120VAC	17W
	XE	CANOPY: CIRCULAR CANOPY LED FIXTURE, 28W LED, DLC LISTED, BLACK FINISH.	ILP	UFO-28WLED-UNIV-40	LED-4000K	120VAC	28W
	XF	LIGHT STANDARD: TYPE 3 DISTRIBUTION, 12,000 LUMENS, HOUSE SIDE SHIELD, DLC LISTED, DARK SKY COMPLIANT, MOUNT FIXTURE AT 3.96m, BIRD SPIKES, BLACK FINISH. POLE: ALUMINUM, SQUARE, NON-TAPERED, 4\"/>	ILP	SAS-12L-U-40-T3-HSS-SAS/BIRD	LED-4000K	120VAC	82W
	XG	LIGHT STANDARD: TYPE 4 DISTRIBUTION, 9,000 LUMENS, HOUSE SIDE SHIELD, DLC LISTED, DARK SKY COMPLIANT, MOUNT FIXTURE AT 3.96m, BIRD SPIKES, BLACK FINISH. POLE: ALUMINUM, SQUARE, NON-TAPERED, 4\"/>	ILP	SAS-9L-U-40-T4-HSS-SAS/BIRD	LED-4000K	120VAC	70W
	XH	WALL PACK: TYPE 2 DISTRIBUTION, 6,000 LUMENS, FULL CUTOFF, HIGH EFFICIENCY, DLC LISTED, DARK SKY COMPLIANT, BLACK FINISH.	ILP	WPCM-6L-U-40-T2	LED-4000K	120VAC	40W
	XJ	WALL PACK: TYPE 4 DISTRIBUTION, 8,000 LUMENS, FULL CUTOFF, HIGH EFFICIENCY, DLC LISTED, DARK SKY COMPLIANT, BLACK FINISH.	ILP	WPCM-8L-U-40-T4	LED-4000K	120VAC	40W
	XK	LIGHT STANDARD: TYPE 4 DISTRIBUTION, 15,000 LUMENS, DLC LISTED, DARK SKY COMPLIANT, MOUNT FIXTURE AT 3.96m, BIRD SPIKES, BLACK FINISH. POLE: ALUMINUM, SQUARE, NON-TAPERED, 4\"/>	ILP	SAS-15L-U-40-T4-SAS/BIRD	LED-4000K	120VAC	108W

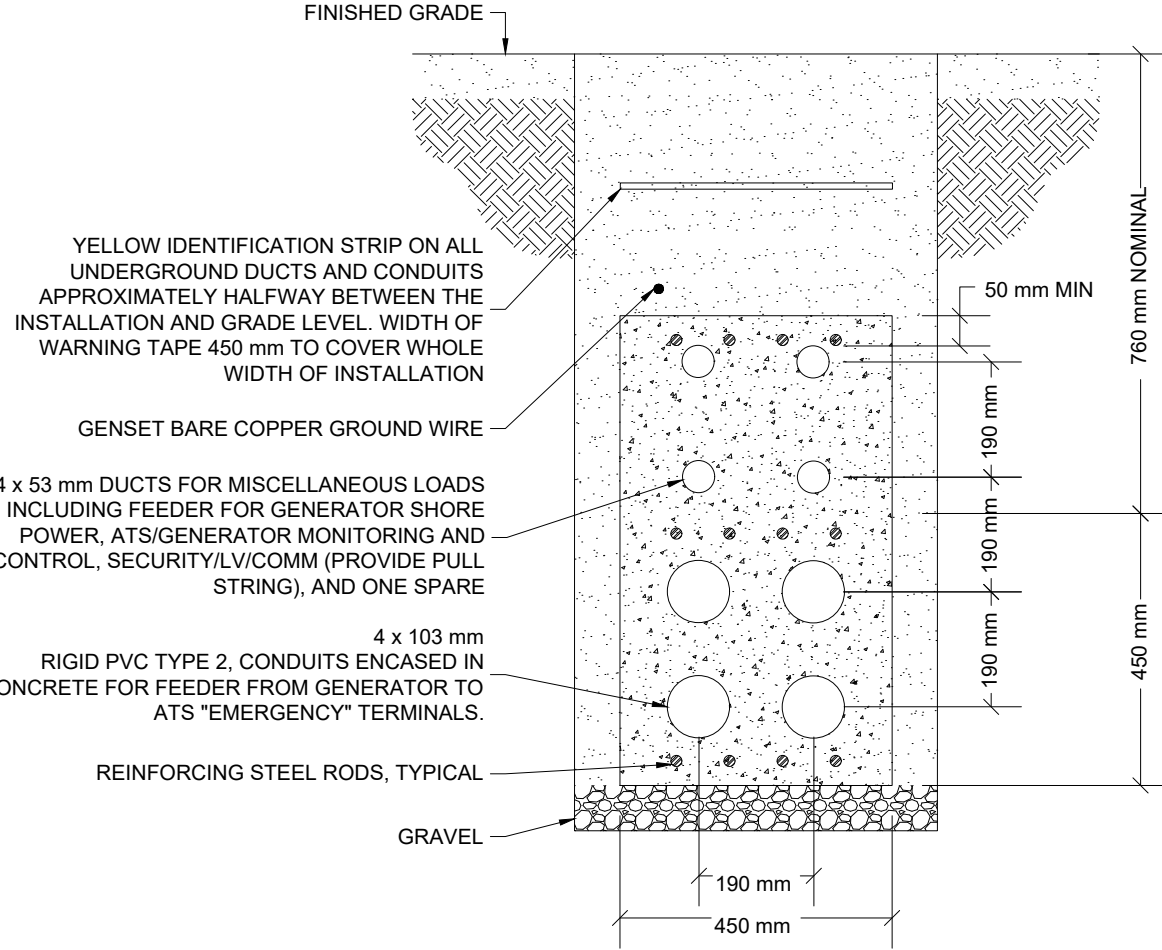

NOTES:

- DUCT BANK TO BE IN COMPLIANCE WITH 2018 ONTARIO ELECTRICAL SAFETY CODE, DIAGRAM D11, DETAIL 4.
- DUCT BANK TO BE INSPECTED PRIOR TO POURING OF CONCRETE AND PRIOR TO BACKFILL. COORDINATE WITH AUTHORITY HAVING JURISDICTION AND RECEIVE ALL NECESSARY APPROVALS.

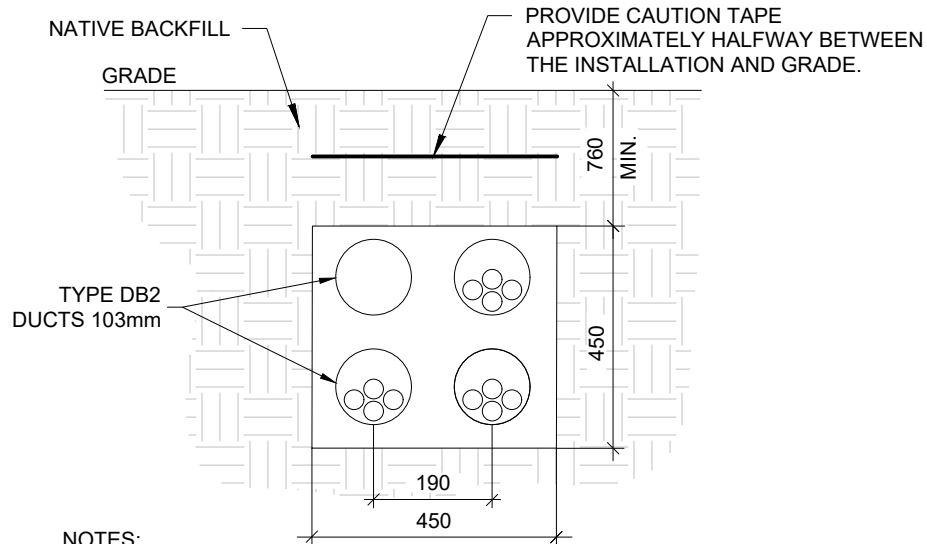

NOTES:

- BASED ON DIAGRAM D11 OF THE ONTARIO ELECTRICAL SAFETY CODE.
- REFER TO SINGLE LINE DIAGRAM FOR CONDUCTOR AND CONDUIT REQUIREMENTS
- SPACE CAUTION TAPE MAXIMUM 600m APART TO COVER FULL WIDTH OF TRENCH.
- 103MM PVC TYPE 2 DUCTS BURIED MIN 610MM FOR COMMUNICATIONS REQUIRED EXACT ROUTING AND TERMINATION TO BE VERIFIED.

Gerrits
ENGINEERING

 
222 Mapleview Drive West, Suite 300
Barrie, ON L4N 9E7 Canada
Tel.: 705.737.3303
Fax.: 705.737.1772
www.gerrits.com

This drawing has been created electronically.

Handwritten or manual revisions to the drawing are only valid when accompanied by the design engineer's initials.

Do not scale drawings.
Check and verify all dimensions and information on the drawings and report all errors or omissions to the Consultant before proceeding with the work. This drawing shall not be reproduced in any manner, in part or in whole, for any project other than that for which it was prepared. This drawing, and all design concepts it contains, are an instrument of professional service and remain the property of Gerrits Engineering.

This drawing may have been reduced.



No.	Issuance Description	YYMMDD
1.	RE-ISSUED FOR SITE PLAN APPROVAL	24/04/26
2.	RE-ISSUED FOR SITE PLAN APPROVAL	24/05/24
3.	ISSUED FOR COORDINATION	24/06/21
4.	RE-ISSUED FOR SITE PLAN APPROVAL	24/06/24
5.	ISSUED FOR COORDINATION	24/07/26
6.	ISSUED FOR COORDINATION	24/08/23
7.	ISSUED FOR SITE PLAN APPROVAL	24/09/11

ISSUED FOR:

SITE PLAN APPROVAL

DRAWINGS ARE 'ISSUED FOR SITE PLAN APPROVAL' AND ARE NOT TO BE USED FOR PERMIT APPLICATIONS OR CONSTRUCTION UNTIL SO AUTHORIZED BY THE CONSULTANT.

Client

MCL ARCHITECTS

Project


ROSE STREET AFFORDABLE
HOUSING

20 Rose Street, Barrie, ON

Drawing:

ELECTRICAL DETAILS (1 OF 2)

Project No. 176-014-23 Designed by: MG Checked by: CP
Time Stamp: Drawn by: MG Approved by: CP
Orientation: Stamp

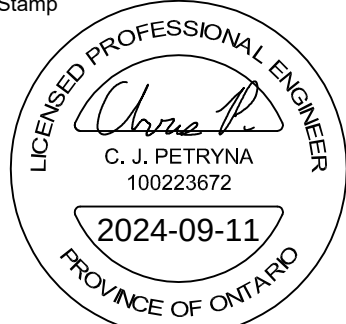

Drawing No.

E-103

