
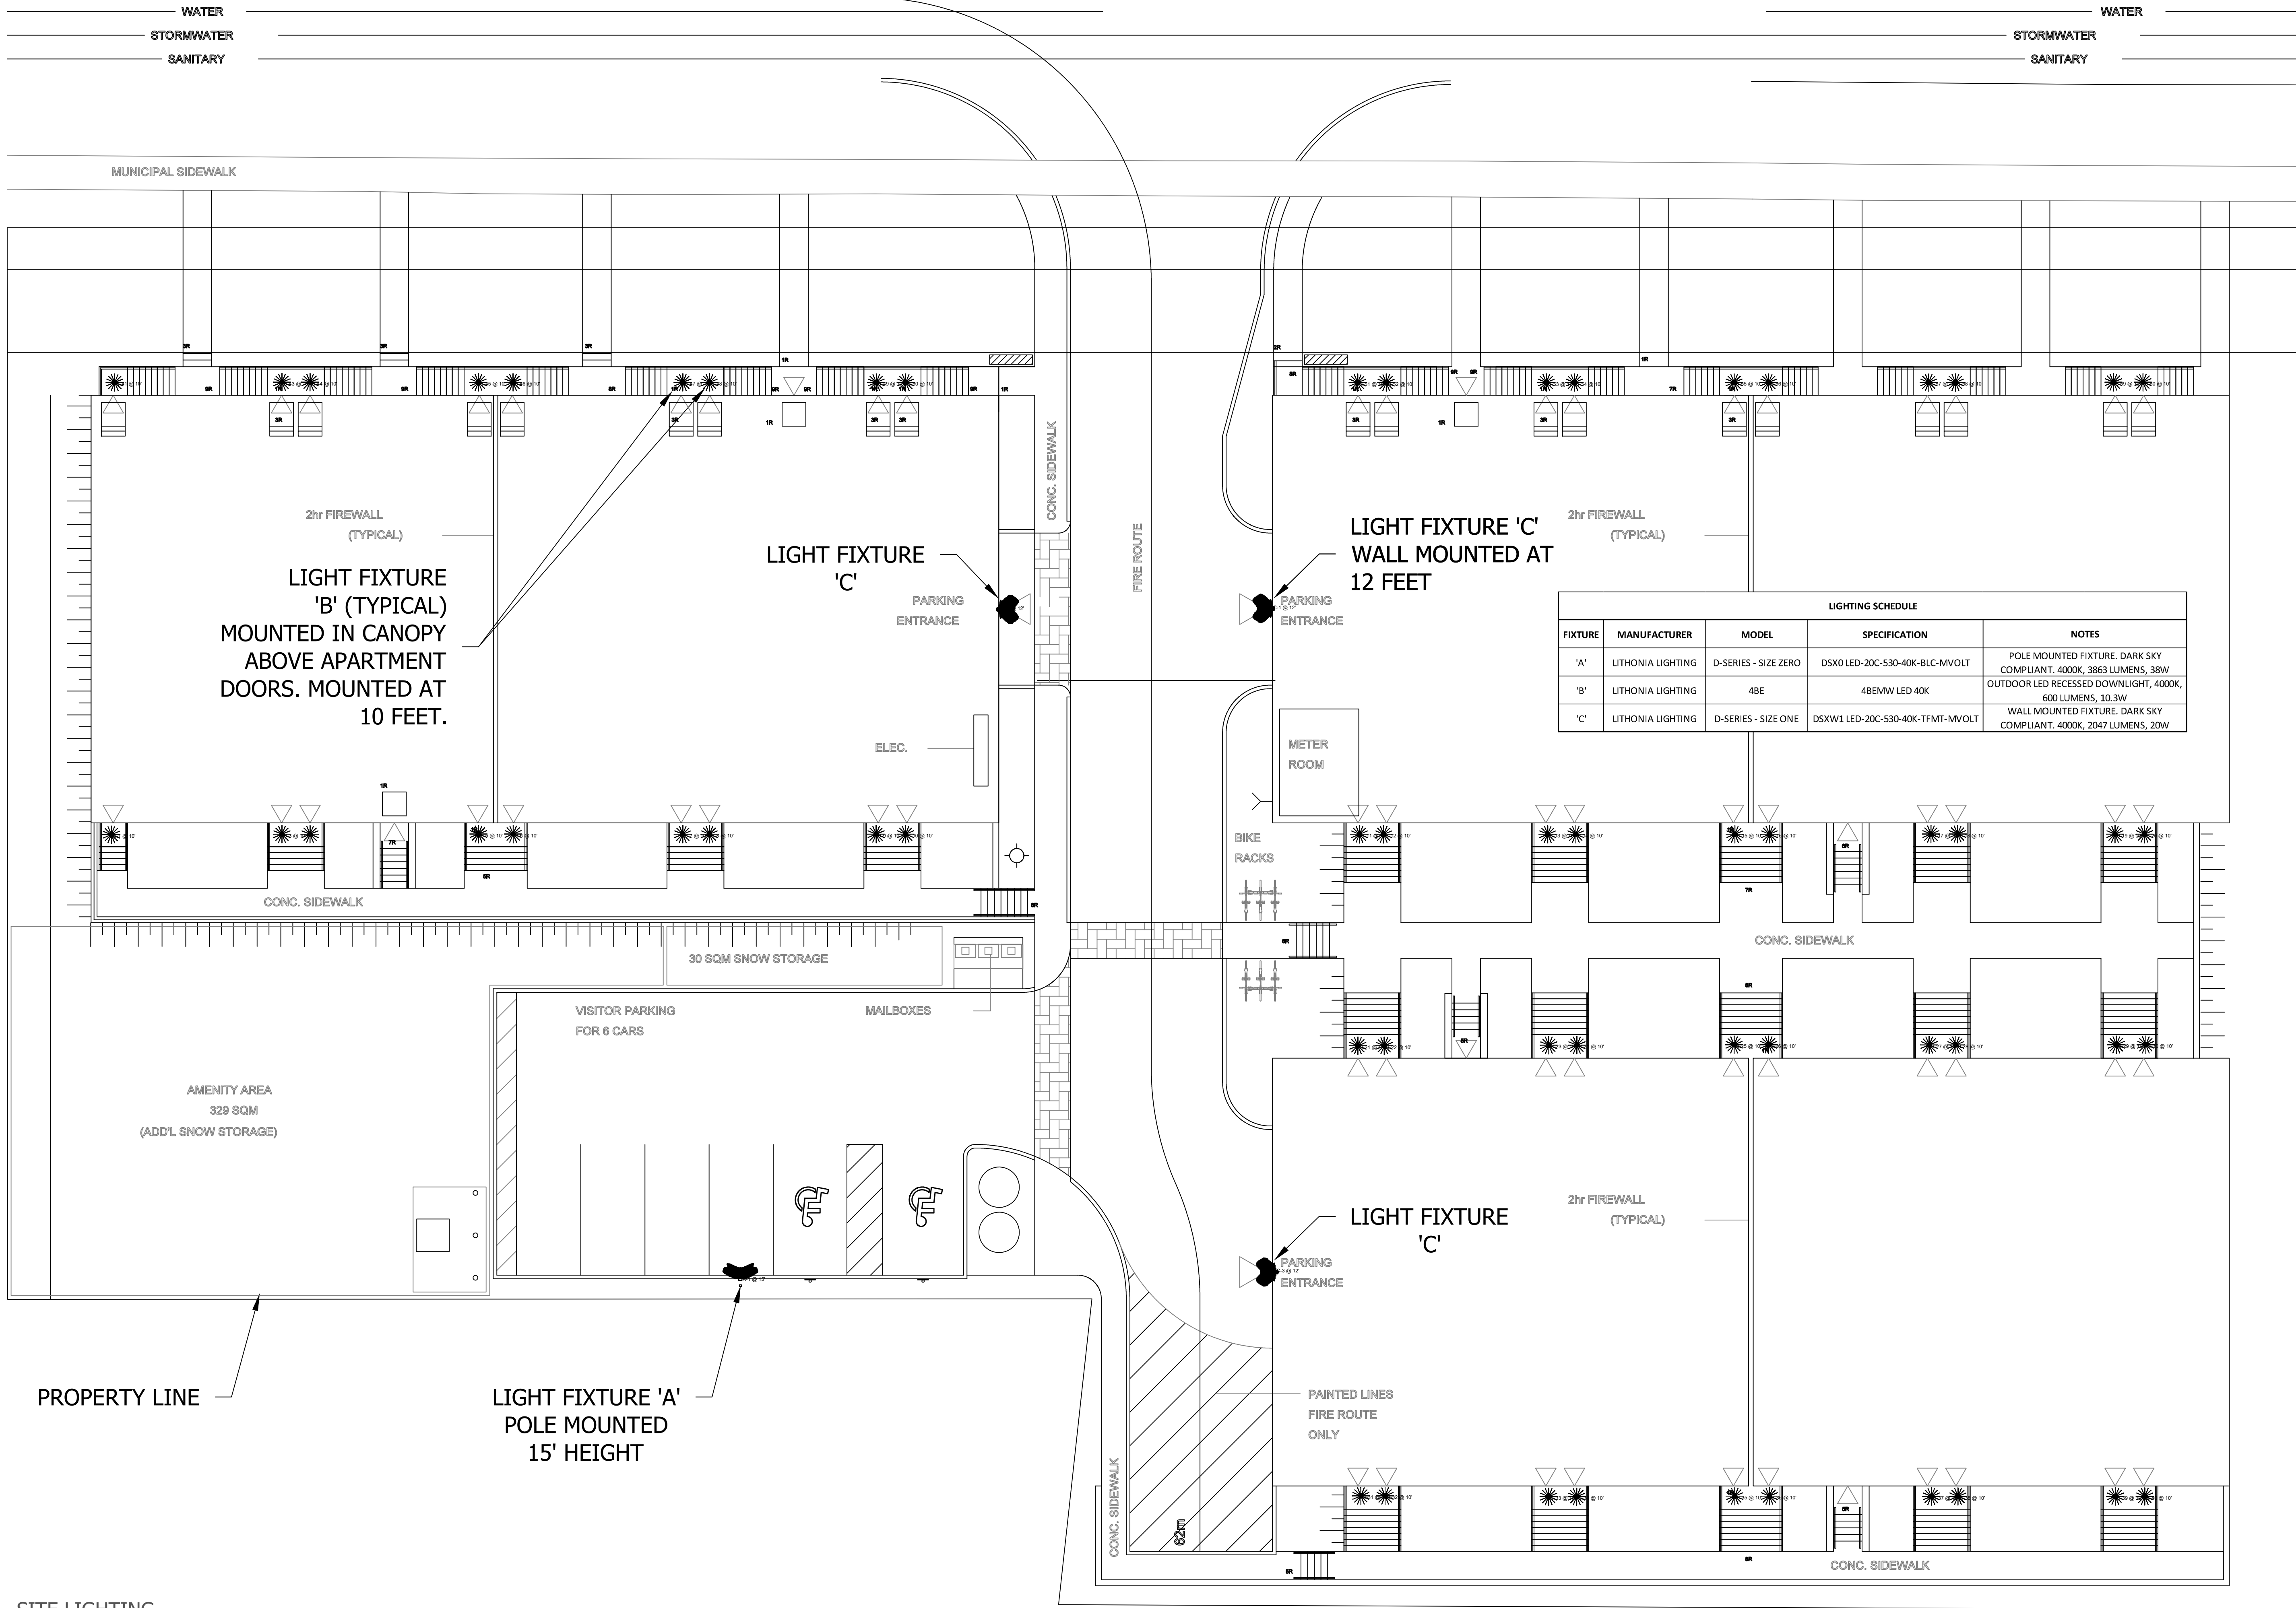


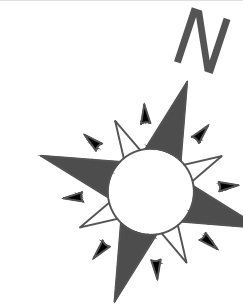


LIGHTING SCHEDULE				
FIXTURE	MANUFACTURER	MODEL	SPECIFICATION	NOTES
'A'	LITHONIA LIGHTING	D-SERIES - SIZE ZERO	DSX0 LED-20C-530-40K-BLC-MVOLT	POLE MOUNTED FIXTURE. DARK SKY COMPLIANT. 4000K, 3863 LUMENS, 38W
'B'	LITHONIA LIGHTING	4BE	4BEMW LED-40K	OUTDOOR LED RECESSED DOWNLIGHT, 4000K, 600 LUMENS, 10.3W
'C'	LITHONIA LIGHTING	D-SERIES - SIZE ONE	DSXW1 LED-20C-530-40K-TFMT-MVOLT	WALL MOUNTED FIXTURE. DARK SKY COMPLIANT. 4000K, 2047 LUMENS, 20W

DATE	NO.	DESCRIPTION	BY
SEP. 05/18	2	RE-ISSUED FOR PERMIT	AR
SEP. 14/17	1	ISSUED FOR PERMIT	AR

MARK VOID ALL PRINTS DATED PREVIOUS TO FINAL DATE ABOVE			
REVISIONS			

CONTRACTOR MUST CHECK AND VERIFY ALL DIMENSIONS AND CONDITIONS ON THE JOB AND REPORT DISCREPANCIES TO THE ENGINEERS BEFORE PROCEEDING WITH WORK
THIS DRAWING IS THE PROPERTY OF THE ENGINEERS AND MUST BE RETURNED ON COMPLETION OF THE WORK
DRAWINGS ARE NOT TO BE SCALED

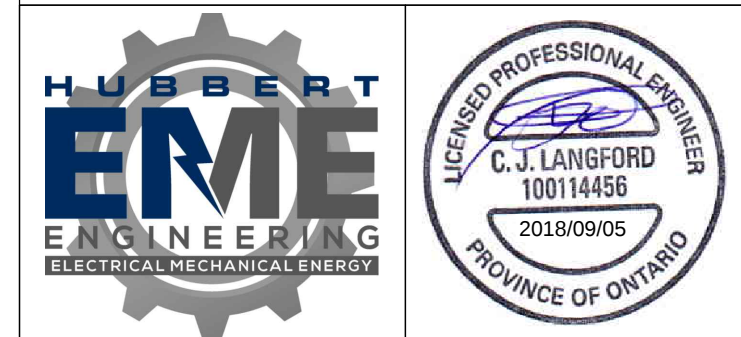



Hubbert EME Engineering
90 WINGES ROAD, UNIT No. 201
VAUGHAN, ON L4L 6A9
TEL: (905)851-5492
EMAIL: doug@EMEeng.com

67 HIGH STREET
BARRIE, ON L4N 1W5
TEL: (705)735-1133
EMAIL: chris@EMEeng.com

DRAWING TITLE
LIGHTING PLAN

PROJECT TITLE
Big Bay Point Towns
521-531 Big Bay Point Road
Barrie, ON

DRAWN BY AR	CHECKED BY CJL	SCALE 3/32"=1'-0"
DATE SEP/2017	PROJECT NUMBER 7-5168	DRAWING NUMBER E.01

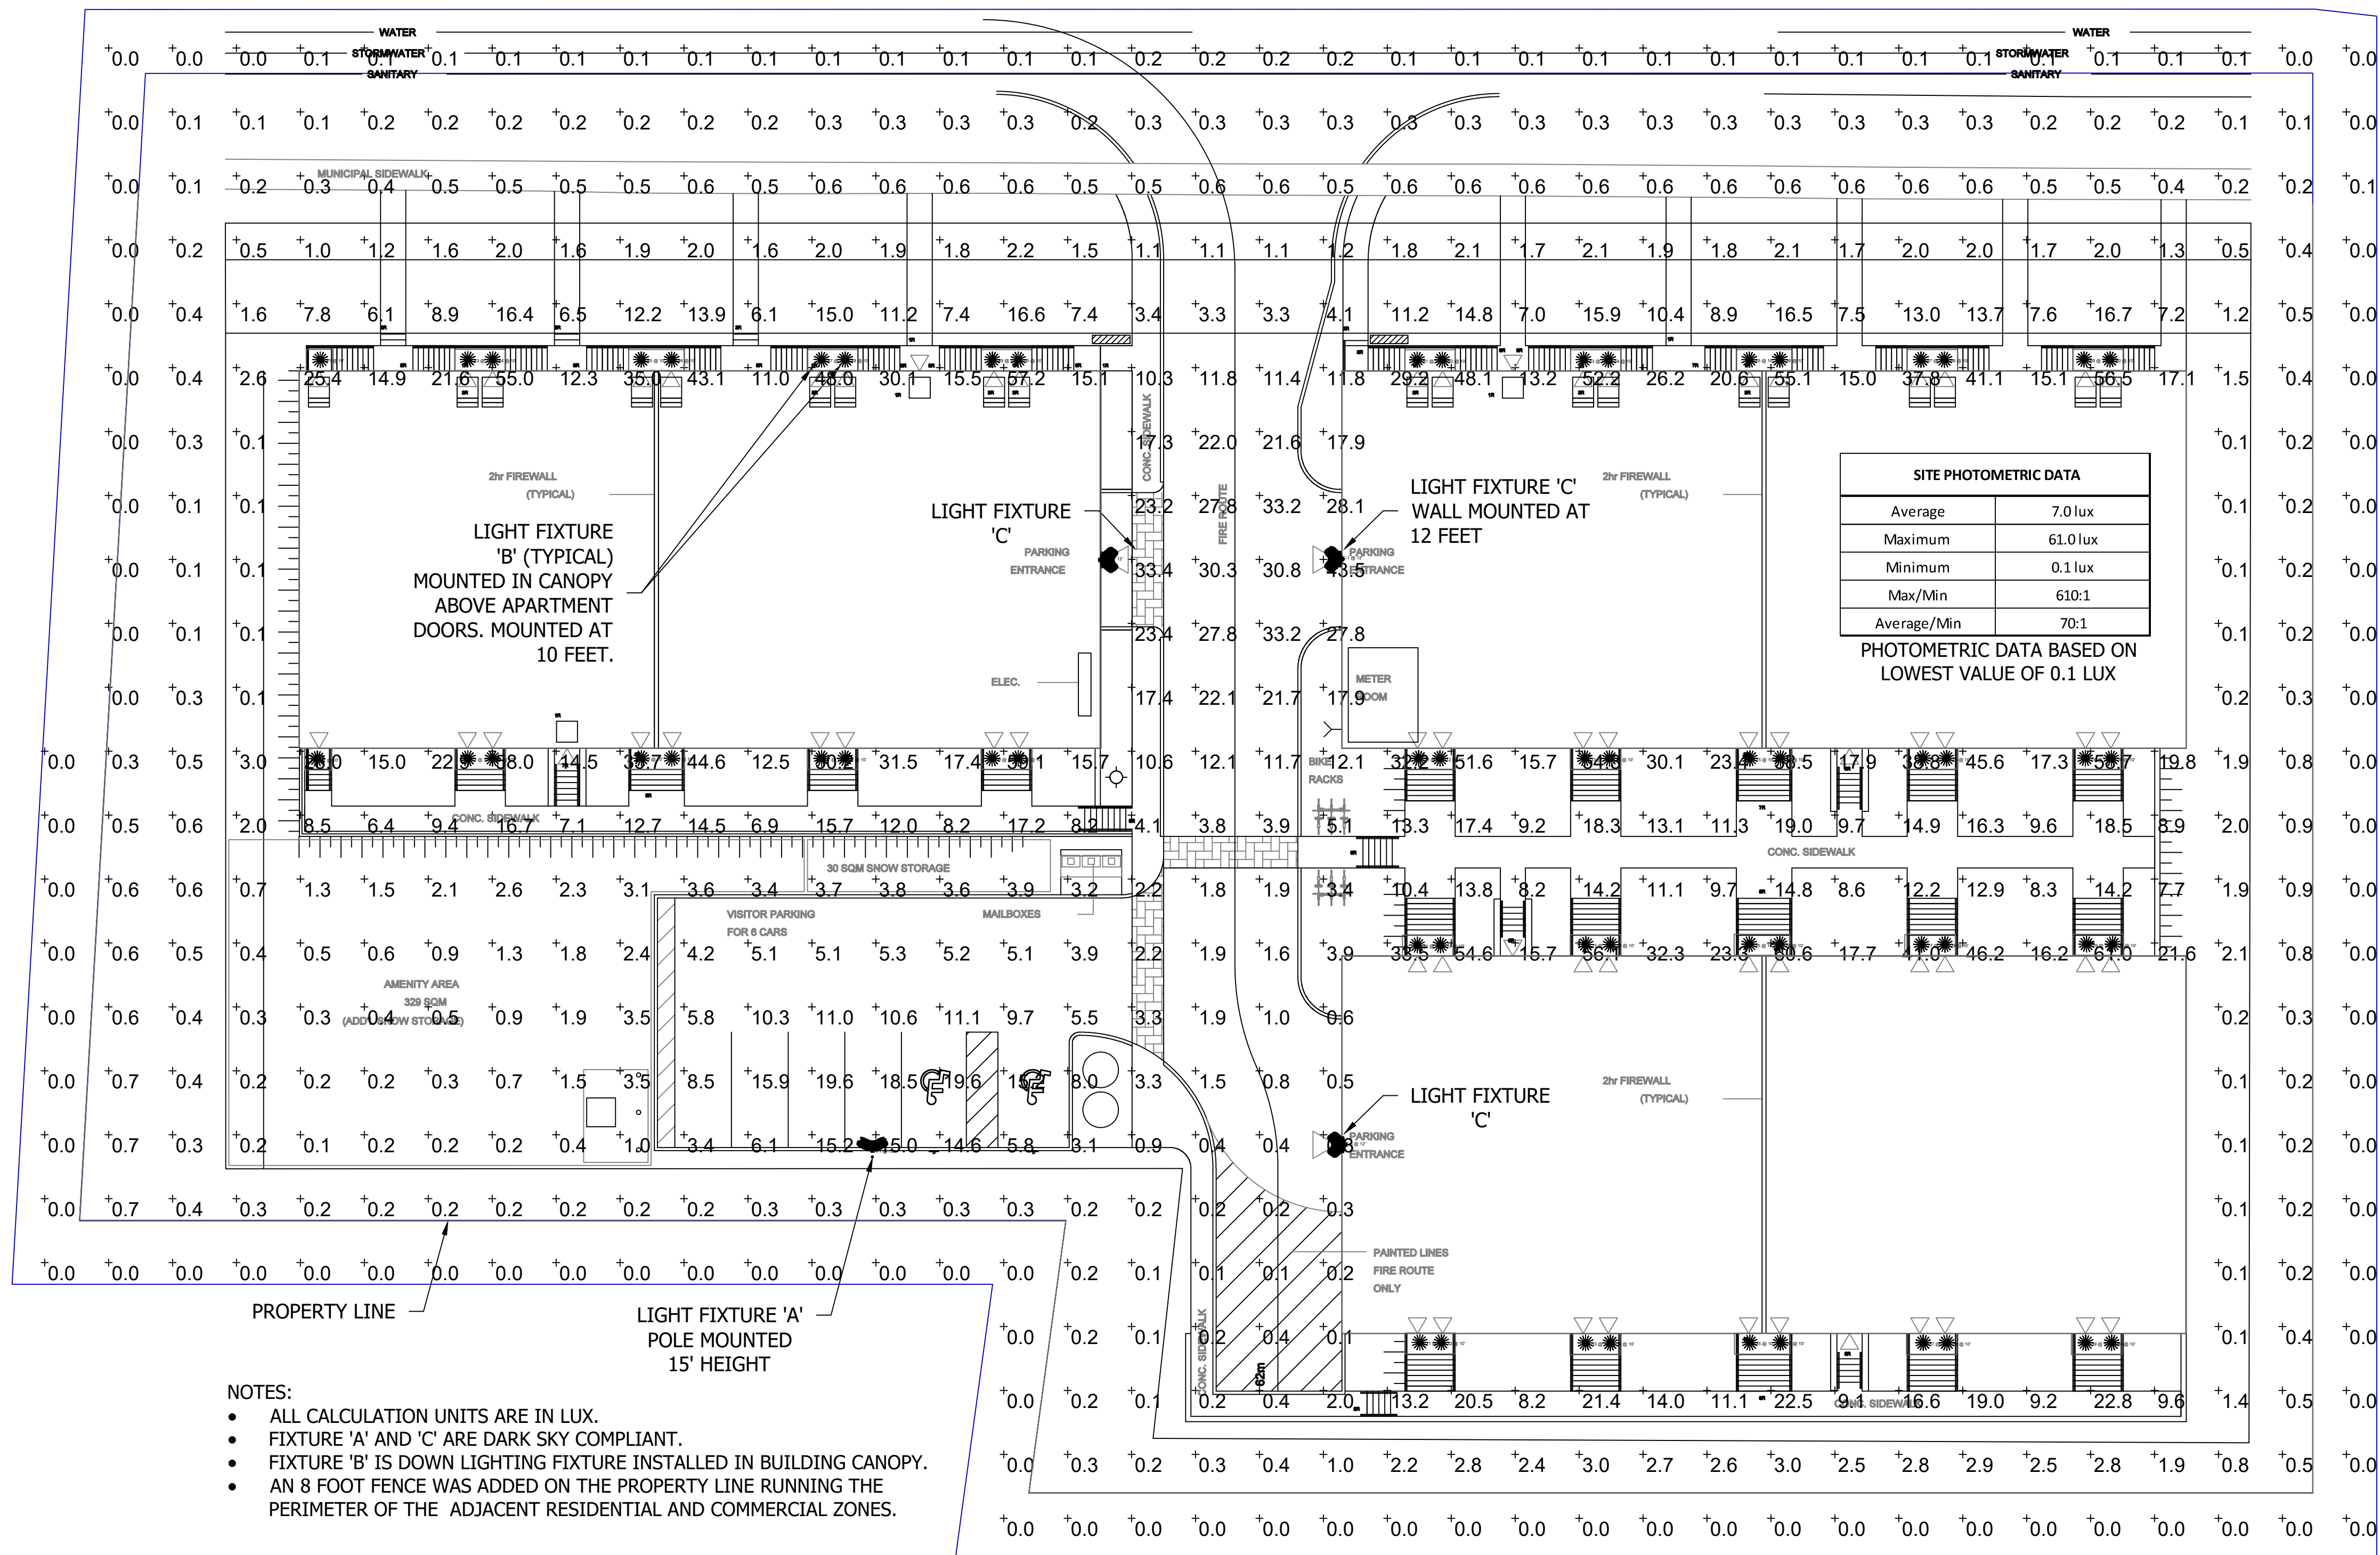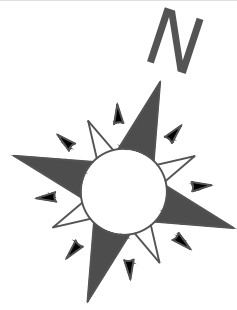

- NOTES:
- ALL CALCULATION UNITS ARE IN LUX.
 - FIXTURE 'A' AND 'C' ARE DARK SKY COMPLIANT.
 - FIXTURE 'B' IS DOWN LIGHTING FIXTURE INSTALLED IN BUILDING CANOPY.
 - AN 8 FOOT FENCE WAS ADDED ON THE PROPERTY LINE RUNNING THE PERIMETER OF THE ADJACENT RESIDENTIAL AND COMMERCIAL ZONES.

SEP. 05/18	2	RE-ISSUED FOR PERMIT	AR
SEP. 14/17	1	ISSUED FOR PERMIT	AR
DATE	NO.	DESCRIPTION	BY

MARK VOID ALL PRINTS DATED PREVIOUS TO FINAL DATE ABOVE			
REVISIONS			
CONTRACTOR MUST CHECK AND VERIFY ALL DIMENSIONS AND CONDITIONS ON THE JOB AND REPORT DISCREPANCIES TO THE ENGINEERS BEFORE PROCEEDING WITH WORK			
THIS DRAWING IS THE PROPERTY OF THE ENGINEERS AND MUST BE RETURNED ON COMPLETION OF THE WORK			
DRAWINGS ARE NOT TO BE SCALED			

Hubbert EME Engineering
ELECTRICAL/MECHANICAL/ENERGY

PROFESSIONAL ENGINEER
C.J. LANGFORD
100114456
2018/09/05
PROVINCE OF ONTARIO

Hubbert EME Engineering		
90 WINGES ROAD, UNIT No. 201 VAUGHAN, ON L4L 6A9 TEL: (905)851-5492 EMAIL: doug@EMEEng.com		
67 HIGH STREET BARRIE, ON L4N 1W5 TEL: (705)735-1133 EMAIL: chris@EMEEng.com		
DRAWING TITLE		
PHOTOMETRIC PLAN		
PROJECT TITLE		
Big Bay Point Towns 521-531 Big Bay Point Road Barrie, ON		
DRAWN BY	CHECKED BY	SCALE
AR	CJL	1/16"=1'-0"
DATE	PROJECT NUMBER	DRAWING NUMBER
SEP/2017	7-5168	E.02