


PLANT SCHEDULE PRIVATE

DECIDUOUS TREES	CODE	QTY	BOTANICAL NAME	COMMON NAME	B&B	CAL	REMARKS
	ACA	9	ACER CAMPESTRE	HEDGE MAPLE 'EVELLY'	B & B	60MM CAL	DROUGHT TOLERANT
	ARU	8	ACER RUBRUM	RED MAPLE	B & B	70MM CAL	NATIVE
	AMC	2	AMELANCHIER CANADENSIS	MULTI-TRUNK SHADBLow SERVICEBERRY	B & B	50MM CAL	3 CLUMP NATIVE
	QUP	1	QUERCUS PALUSTRIS	PIN OAK	B & B	70MM CAL	NATIVE
EVERGREEN TREES	CODE	QTY	BOTANICAL NAME	COMMON NAME	B&B	CAL	REMARKS
	JCB	4	JUNIPERUS CHINENSIS 'BLUE POINT'	BLUE POINT JUNIPER	B & B	1.8M HT.	DROUGHT TOLERANT
	PPG	10	PICEA PLUNGENS GLAUCA	COLORADO BLUE SPRUCE	B & B	2M HT.	DROUGHT TOLERANT
DECIDUOUS SHRUBS	CODE	QTY	BOTANICAL NAME	COMMON NAME	CONT.	HT	REMARKS
	csk	73	CORNUS SERICEA 'KELSEY'	KELSEY DOGWOOD	CONT.	60 CM	
	efe	119	EUONYMUS FORTUNEI 'EMERALD GAIETY' TM	EMERALD GAIETY EUONYMUS	3 GAL.	60 CM	DROUGHT TOLERANT
	pgg	43	PHYSOCARPUS OPLULIFOLIUS 'GOLDEN NUGGET'	GOLDEN NUGGET NINEBARK	CONT.	80 CM	DROUGHT TOLERANT
	nwp	12	ROSA X 'WINPEG PARKS'	WINPEG PARKS ROSE	3 GAL.	60 CM	
	sbq	76	SPIRAEA X BUNALDA 'GOLDFLAME'	GOLDFLAME SPIREA	CONT.	60 CM	
EVERGREEN SHRUBS	CODE	QTY	BOTANICAL NAME	COMMON NAME	CONT.	HT	REMARKS
	jhp	1	JUNIPERUS HORIZONTALIS 'PLUMOSA COMPACTA'	CREeping JUNIPER	CONT.	80CM SPR	DROUGHT TOLERANT
GRASSES	CODE	QTY	BOTANICAL NAME	COMMON NAME	CONT.	SPACING	REMARKS
	-cao	51	CALAMAGROSTIS X ACUTIFLORA 'OVERDAM'	OVERDAM FEATHER REED GRASS	3 GAL.	600mm	DROUGHT TOLERANT
PERENNIALS	CODE	QTY	BOTANICAL NAME	COMMON NAME	CONT.	SPACING	REMARKS
	-aaf	4	ASTILBE X ARENDSII 'FANAL'	FANAL ASTILBE	2 GAL.	600mm	
	-esp	10	ECHINACEA PURPUREA	PURPLE CONEFLOWER	2 GAL.	300mm	NATIVE, DROUGHT TOLERANT

PLANT SCHEDULE PUBLIC

DECIDUOUS TREES	CODE	QTY	BOTANICAL NAME	COMMON NAME	B&B	CAL	REMARKS
	AMC	3	AMELANCHIER CANADENSIS	MULTI-TRUNK SHADBLow SERVICEBERRY	B & B	50MM CAL	3 CLUMP NATIVE
	AML	14	AMELANCHIER LAEVIS	ALLEGHENY SERVICEBERRY	B & B	40MM CAL	NATIVE
	QUP	9	QUERCUS PALUSTRIS	PIN OAK	B & B	70MM CAL	NATIVE
EVERGREEN TREES	CODE	QTY	BOTANICAL NAME	COMMON NAME	B&B	CAL	REMARKS
	JCB	1	JUNIPERUS CHINENSIS 'BLUE POINT'	BLUE POINT JUNIPER	B & B	1.8M HT.	DROUGHT TOLERANT
	JVB	6	JUNIPERUS VIRGINIANA 'BLUE ARROW'	BLUE ARROW JUNIPER	B & B	1.8M HT.	DROUGHT TOLERANT
SHRUBS	CODE	QTY	BOTANICAL NAME	COMMON NAME	CONT.	HT	REMARKS
	tden	38	TAXUS X MEDIA 'DENSIFORMIS'	DENSE YEW	3 GAL.	60 CM	
DECIDUOUS SHRUBS	CODE	QTY	BOTANICAL NAME	COMMON NAME	CONT.	HT	REMARKS
	csk	141	CORNUS SERICEA 'KELSEY'	KELSEY DOGWOOD	CONT.	60 CM	
	efe	8	EUONYMUS FORTUNEI 'EMERALD GAIETY' TM	EMERALD GAIETY EUONYMUS	3 GAL.	60 CM	DROUGHT TOLERANT
	pgg	37	PHYSOCARPUS OPLULIFOLIUS 'GOLDEN NUGGET'	GOLDEN NUGGET NINEBARK	CONT.	80 CM	DROUGHT TOLERANT
	nwp	17	ROSA X 'WINPEG PARKS'	WINPEG PARKS ROSE	3 GAL.	60 CM	
EVERGREEN SHRUBS	CODE	QTY	BOTANICAL NAME	COMMON NAME	CONT.	HT	REMARKS
	jhp	117	JUNIPERUS HORIZONTALIS 'PLUMOSA COMPACTA'	CREeping JUNIPER	CONT.	80CM SPR	DROUGHT TOLERANT
GRASSES	CODE	QTY	BOTANICAL NAME	COMMON NAME	CONT.	SPACING	REMARKS
	-cao	50	CALAMAGROSTIS X ACUTIFLORA 'OVERDAM'	OVERDAM FEATHER REED GRASS	2 GAL.	500mm	
PERENNIALS	CODE	QTY	BOTANICAL NAME	COMMON NAME	CONT.	SPACING	REMARKS
	-bi	62	BRUNNERA MACROPHYLLA 'LOOKING GLASS'	SIBERIAN BUGLOSS	2 GAL.	300mm	
	-ger	211	GERANIUM PSILOSTEMON 'ROZANNE'	ARMENIAN CRANESBILL	2 GAL.	350mm	
	hem	50	HEMEROCALLIS X 'STELLA DE ORO'	STELLA DE ORO DAYLILY	2 GAL.	600mm	
	-hem	162	HEMEROCALLIS X 'STELLA D'ORO'	DAYLILY	2 GAL.	450mm	

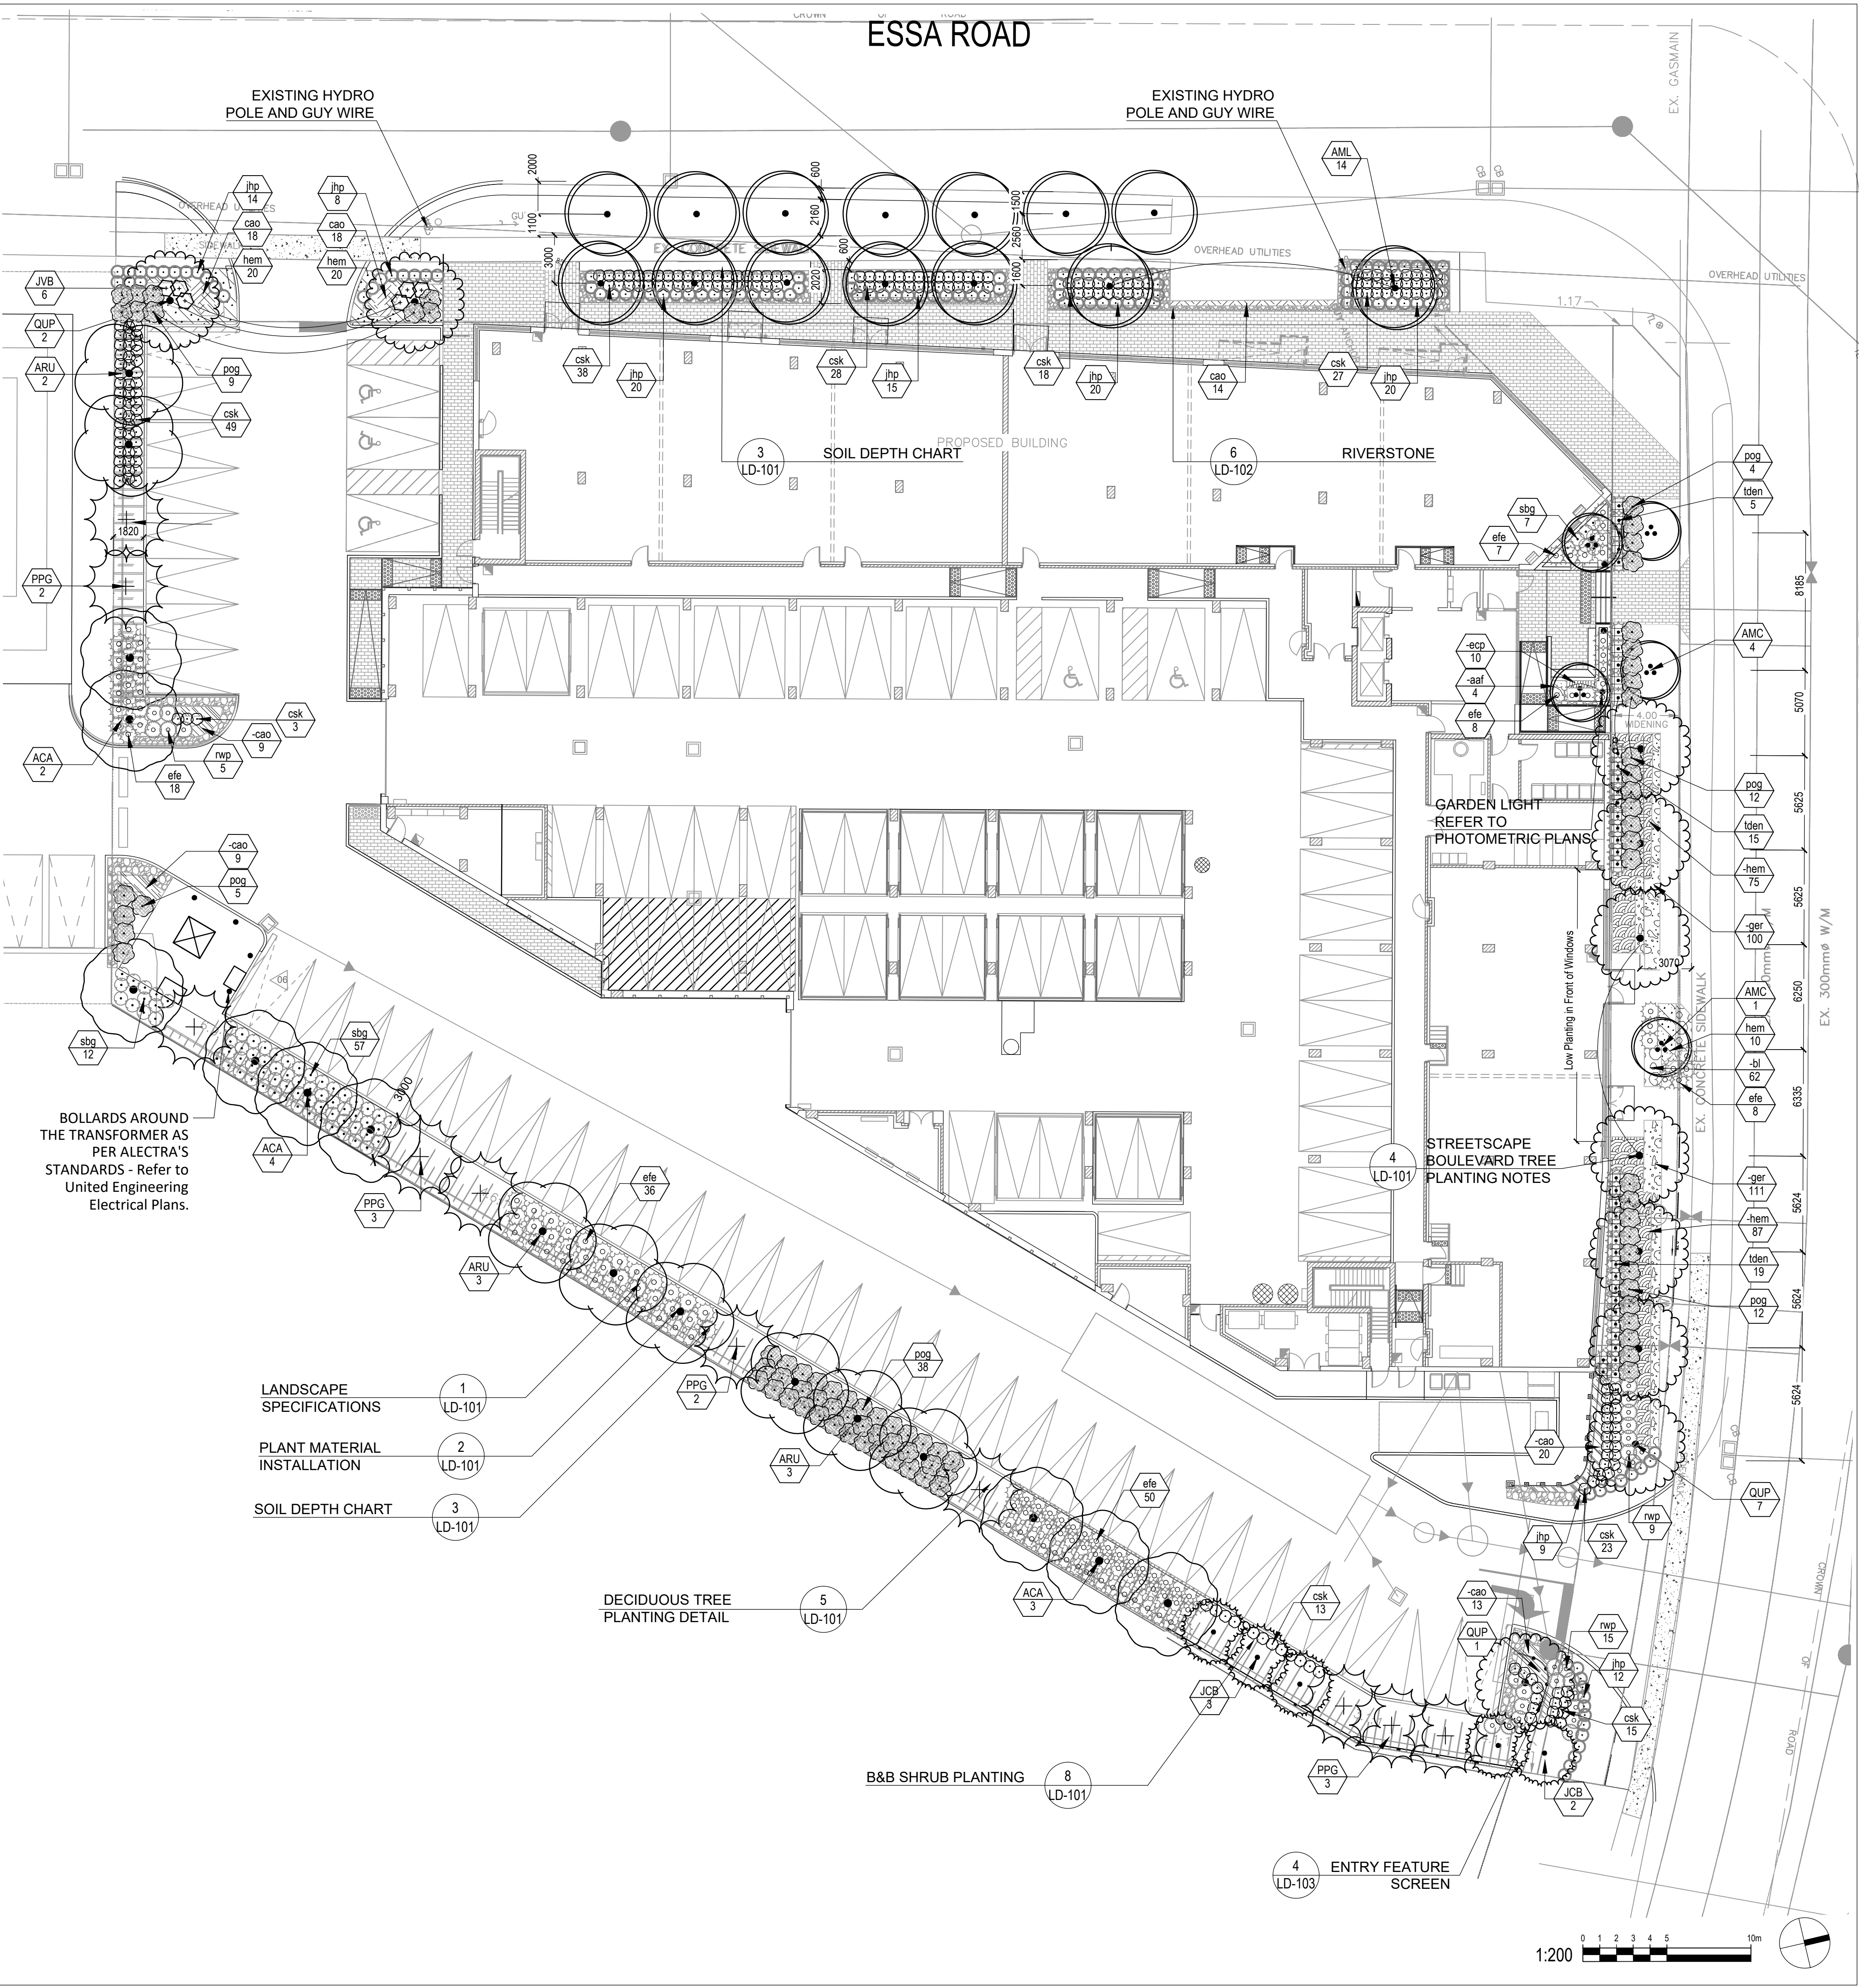

NOT FOR CONSTRUCTION

LEGEND

- UNIT PAVING
- PROPOSED CONCRETE
- SOD
- WOOD TOP SEAT & PLANTER

Lighting - For Photometrics and all light fixture types refer to lighting plans by United Engineering.

- GARDEN LIGHT

no.	revision	date	by
09	ISSUED FOR SITE PLAN REVIEW	2019-08-06	TL
08	ISSUED FOR CONTRACTOR REVIEW	2019-03-04	TL
07	REISSUED FOR SITE PLAN REVIEW	2018-05-01	TL
06	REISSUED FOR SITE PLAN REVIEW	2018-04-13	CL
05	RE-ISSUED FOR ALECTRA'S REVIEW	2018-04-09	CL
04	REISSUED FOR SITE PLAN REVIEW	2018-03-20	CL
03	REISSUED FOR SITE PLAN REVIEW	2017-12-15	CL
02	ISSUED FOR REVIEW	2017-11-24	CL
01	ISSUED FOR SITE PLAN REVIEW	2017-09-21	CL

CONTRACTOR MUST VERIFY ALL DIMENSIONS ON THE JOB AND REPORT ANY DISCREPANCY TO THE LANDSCAPE ARCHITECT BEFORE PROCEEDING WITH THE WORK. ALL DRAWINGS AND SPECIFICATIONS ARE INSTRUMENTS OF SERVICE AND THE PROPERTY OF THE LANDSCAPE ARCHITECT WHICH MUST BE RETURNED AT THE COMPLETION OF THE WORK. ALL DRAWINGS TO BE USED FOR CONSTRUCTION ONLY WHEN SIGNED BY THE LANDSCAPE ARCHITECT.

signed _____ date _____

K:\00 Marketing\001 BOLLERPLATE.sgn\STUDIO\WESTWOOD TLA.sgn_2019.rvt

20 Champlain Blvd. Suite 102 - Toronto ON - M3H 2T1
info@terraplan.ca www.terraplan.ca

U

One Urban Developments Inc.
28 Rivalda Road Toronto,
Ontario M9M 2M3 Canada

CLIENT

430 ESSA ROAD
BARRIE, ONTARIO

PROJECT
PLANTING PLAN

DRAWING	
DRAWN:	CAL
CHECKED:	CL + PM
SCALE:	1:200
DATE:	2017-09-21
PROJECT NO.:	17-145

LP-102

SHEET NO.: